

## Sheet Index

G1.0	General Data / Index
G2.0	Climate Charts
G3.0	Area Calculations
C1.1	Site Plan & Section
A0.0	Diagrams & Sketches
A1.1	Floor Plan
A2.1	Elevation
A2.2	Elevation
A3.1	Transverse Section
A3.2	Transverse Section
A3.3	Longitudinal Section
A4.01	Wall Section
A4.02	Wall Section
A4.03	Wall Section
A4.04	Wall Section
A4.05	Wall Section
A5.01	Critical Detail
A5.01	Critical Detail
S1.1	Footing Plan
S1.2	Footing Section & Detail
S1.3	Structure Floor Framing
S1.4	Structure Roof Framing
S1.5	Structure Overview
M1.0	Thermal Control Diagram
M1.1	Passive Lighting Diagram
M1.2	Passive Lighting Diagram

# Climatic Data



Daylight Chart - Dawn, Dusk, Sunlight, Dark



Surface Meteorology Table - Solar Energy, Visiblity, Temperature, Wind, Precipitation

Variable	J	F	M	A	M	J	J	A	S	O	N	D
Insolation, kWh/m <sup>2</sup> /day	5.25	5.48	5.11	5.22	4.94	4.86	5.03	5.58	5.45	5.07	4.82	4.82
Clearness, 0 - 1	0.46	0.50	0.50	0.58	0.62	0.66	0.67	0.66	0.60	0.51	0.46	0.43
Temperature, °F	73.76	74.17	74.05	74.75	74.26	71.87	72.21	75.78	80.17	78.12	75.11	74.16
Wind speed, mph	9.91	11.27	9.91	10.02	10.02	10.00	10.09	9.89	9.89	9.98	9.98	10.00
Precipitation, in	9.78	8.56	7.39	4.84	1.45	0.33	0.41	0.47	1.95	6.59	9.23	10.26
Wet days, d	25.6	23.2	21.3	12.2	4.7	2.0	2.9	3.7	6.9	17.1	22.0	25.6


These data were obtained from the NASA Langley Research Center Atmospheric Science Data Center; New et al. 2002

Sun Table - Sunrise, Sunset, Dawn, Dusk

Date	Sunrise	Sunset	Length	Change	Dawn	Dusk	Length	Change
Today	6:12am	6:36pm	12:24		5:50am	6:57pm	13:07	
+1 day	6:12am	6:35pm	12:23	00:01 shorter	5:51am	6:57pm	13:06	00:01 shorter
+1 week	6:14am	6:31pm	12:17	00:07 shorter	5:52am	6:53pm	13:01	00:06 shorter
+2 weeks	6:15am	6:26pm	12:11	00:13 shorter	5:53am	6:47pm	12:54	00:13 shorter
+1 month	6:17am	6:14pm	11:57	00:27 shorter	5:56am	6:36pm	12:40	00:27 shorter
+2 months	6:22am	5:55pm	11:33	00:51 shorter	6:00am	6:17pm	12:17	00:50 shorter
+3 months	6:31am	5:47pm	11:16	01:08 shorter	6:08am	6:10pm	12:02	01:05 shorter
+6 months	6:19am	6:06pm	11:47	00:37 shorter	5:57am	6:27pm	12:30	00:37 shorter

Notes: Daylight saving time, \* = Next day.

Sun Path Diagram

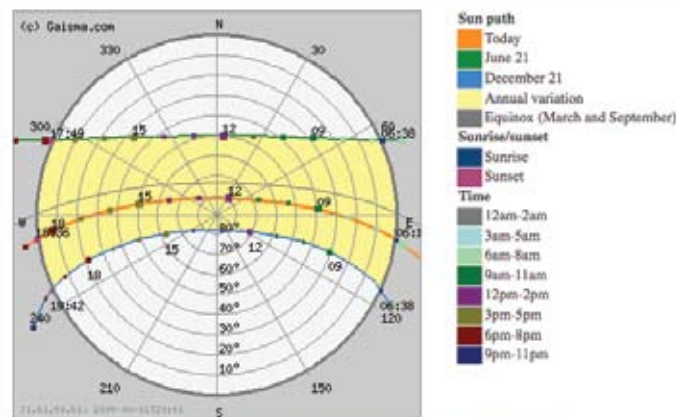


Notes: \* = Daylight saving time, \* = Next day.


## Brasilia, Brazil

Latitude: 15°47'S Longitude: 047°56'W Elevation: 1160m Station: BZ83377

Temperature Chart

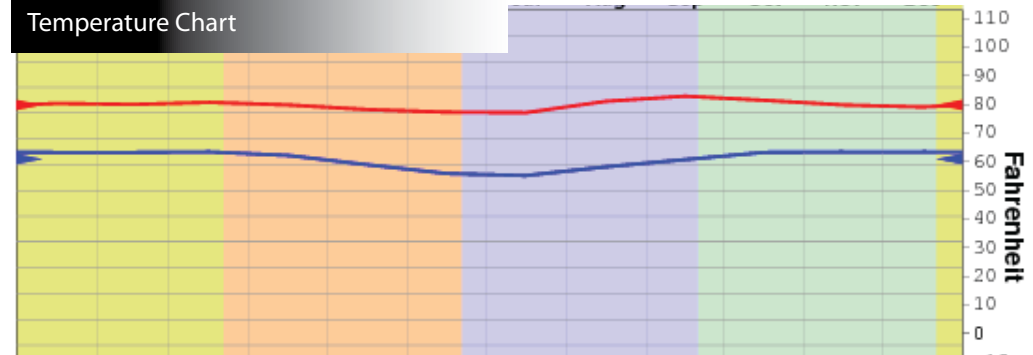

Precipitation Chart

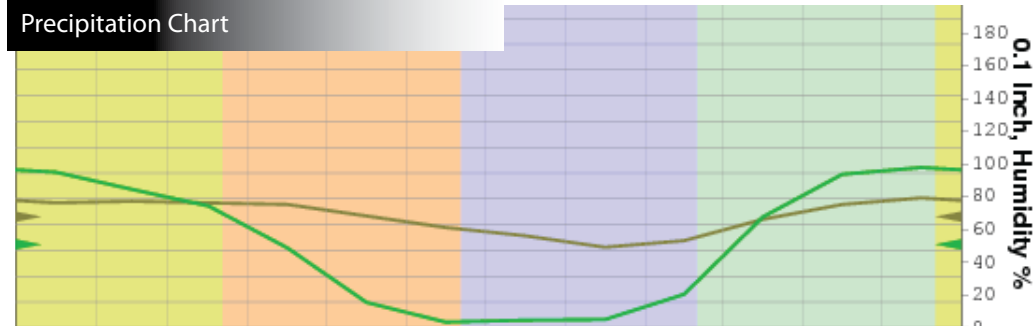

MATERIALS AND ASSEMBLY  
HOT & HUMID  
BRASILIA, BRAZIL

G2.0  
Climate Charts


FINAL SUBMISSION  
APRIL 23,  
2009

Sara Gotschewski  
Kevin Rodriguez  
Ryan Ralston



□ Venturi effect in Low pressure area caused by cross ventilation

■ Cross ventilation

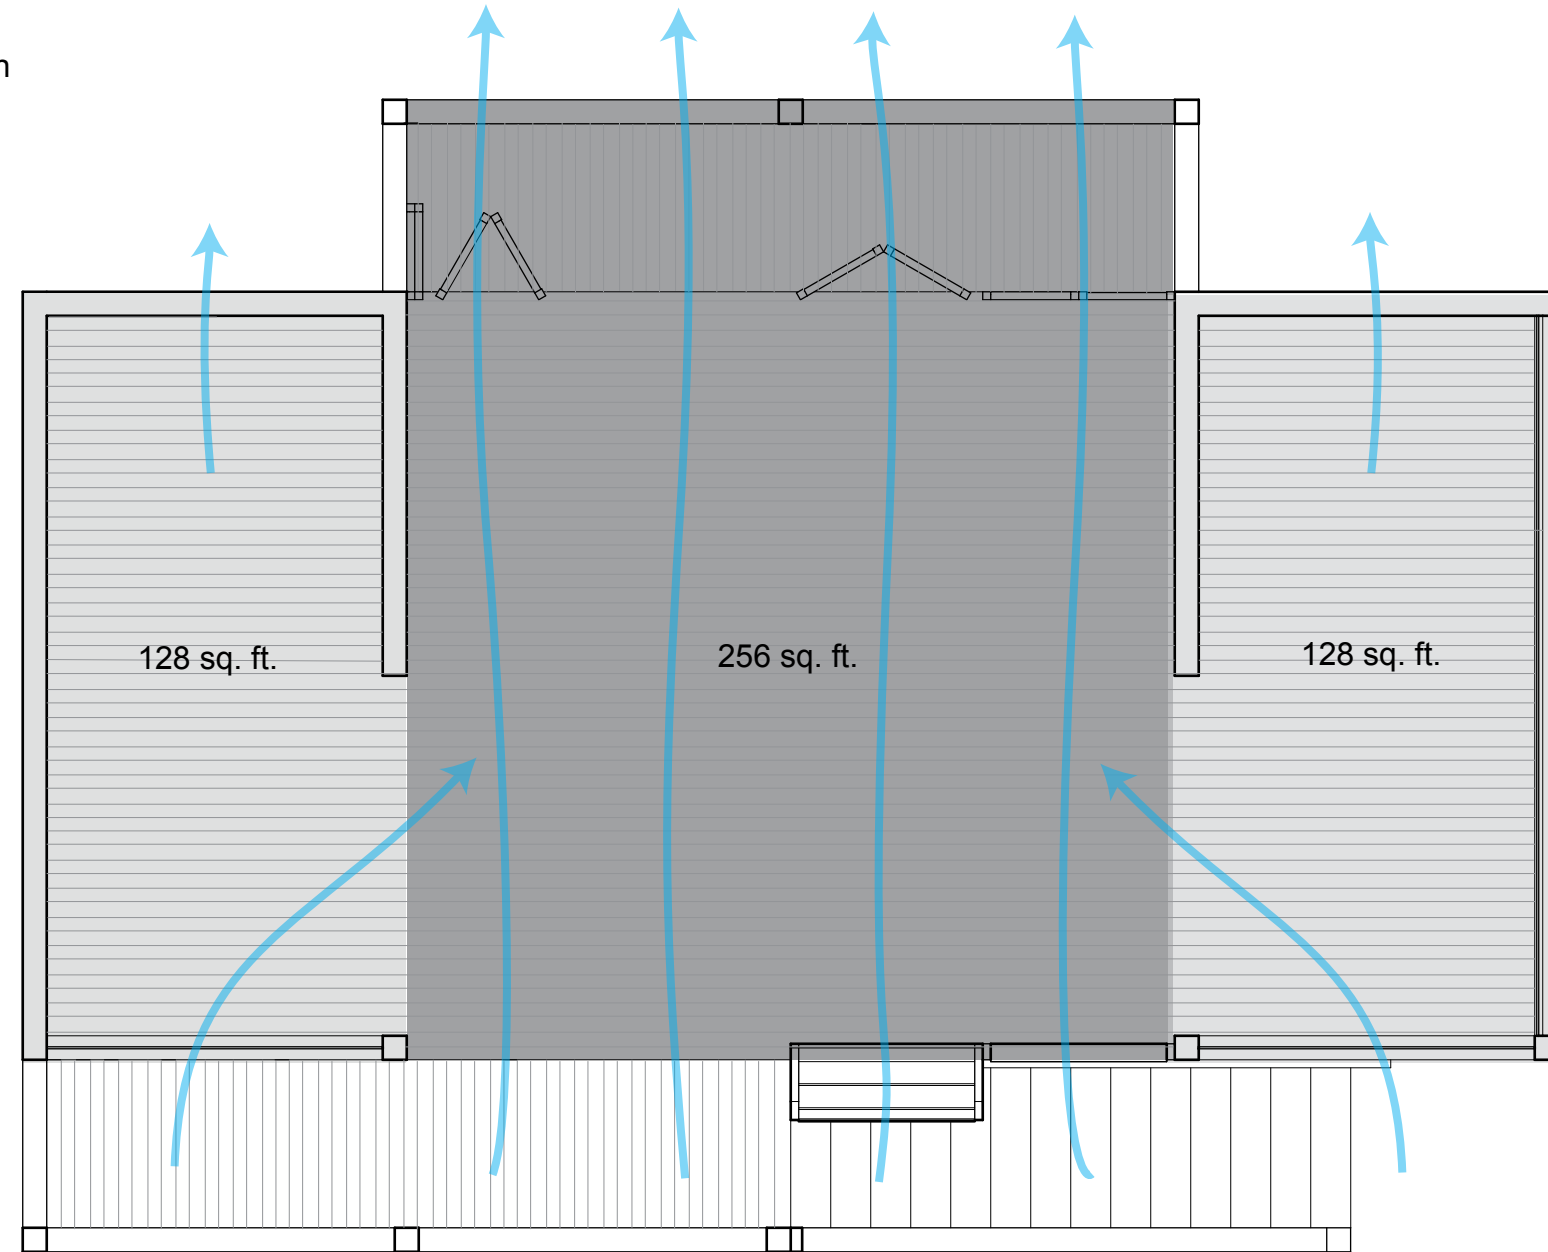

MATERIALS AND ASSEMBLY  
HOT & HUMID  
BRASILIA, BRAZIL

G3.0  
Area Calculations


FINAL SUBMISSION  
APRIL 23,  
2009

Sara Gotschewski  
Kevin Rodriguez  
Ryan Ralston

SKR  
ARCHITECTS

1 AREA CALCULATIONS

SCALE 1/4" = 1'

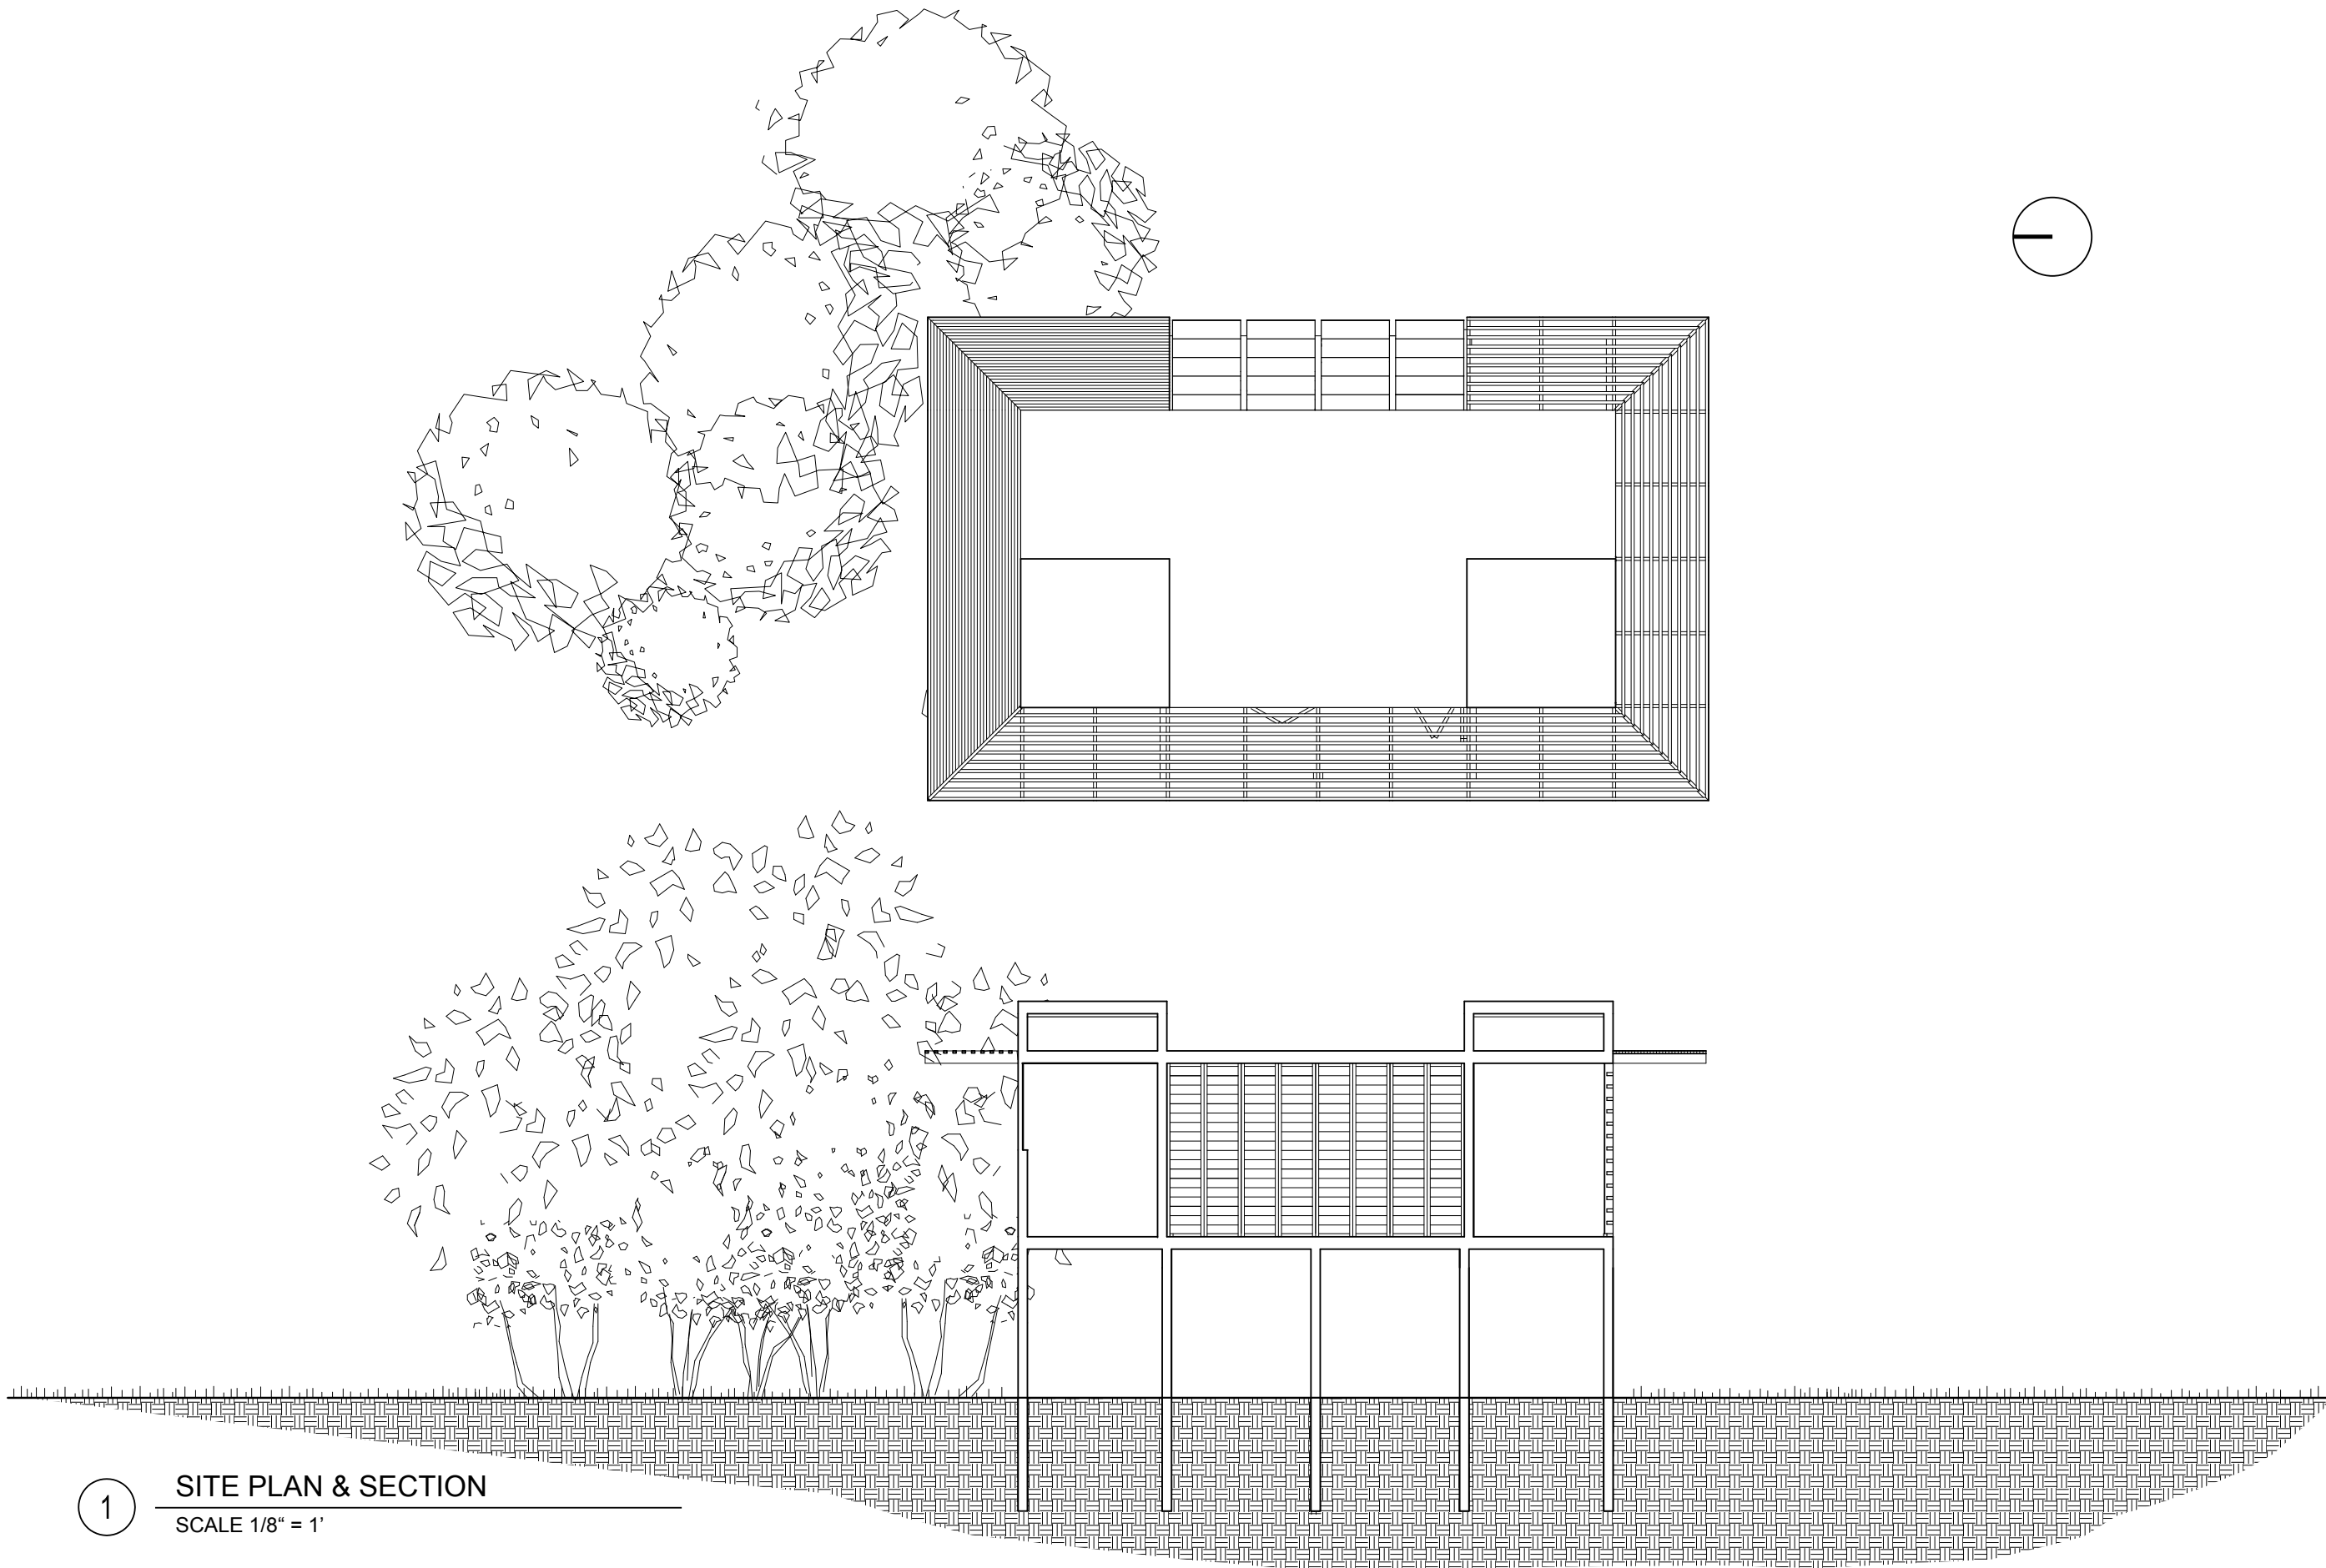

1

SITE PLAN & SECTION

SCALE 1/8" = 1'

MATERIALS AND ASSEMBLY  
HOT & HUMID  
BRASILIA, BRAZIL

C1.1  
Site Plan & Section

FINAL SUBMISSION  
APRIL 23,  
2009

Sara Gotschewski





Kevin Rodriguez

Ryan Ralston



SKR  
ARCHITECTS

# INITIAL CONCEPTS AND SKETCHES

# LOOKING AT WIND AND HOW WE COULD USE VENTILATION TO REDUCE HUMIDITY

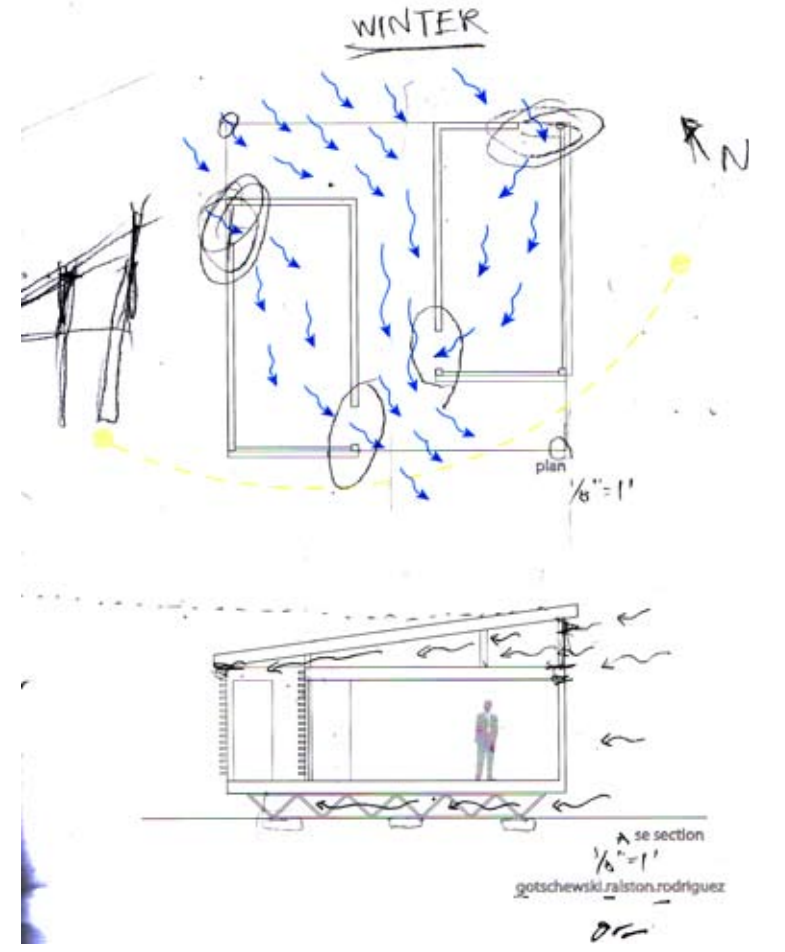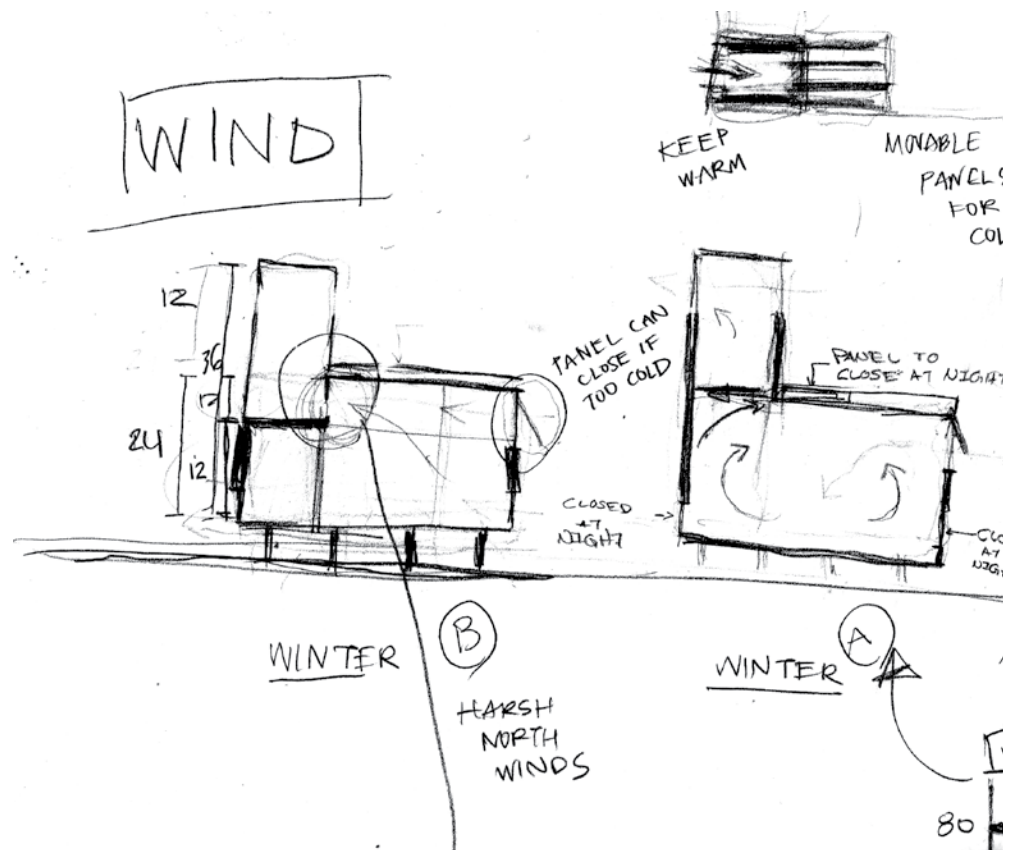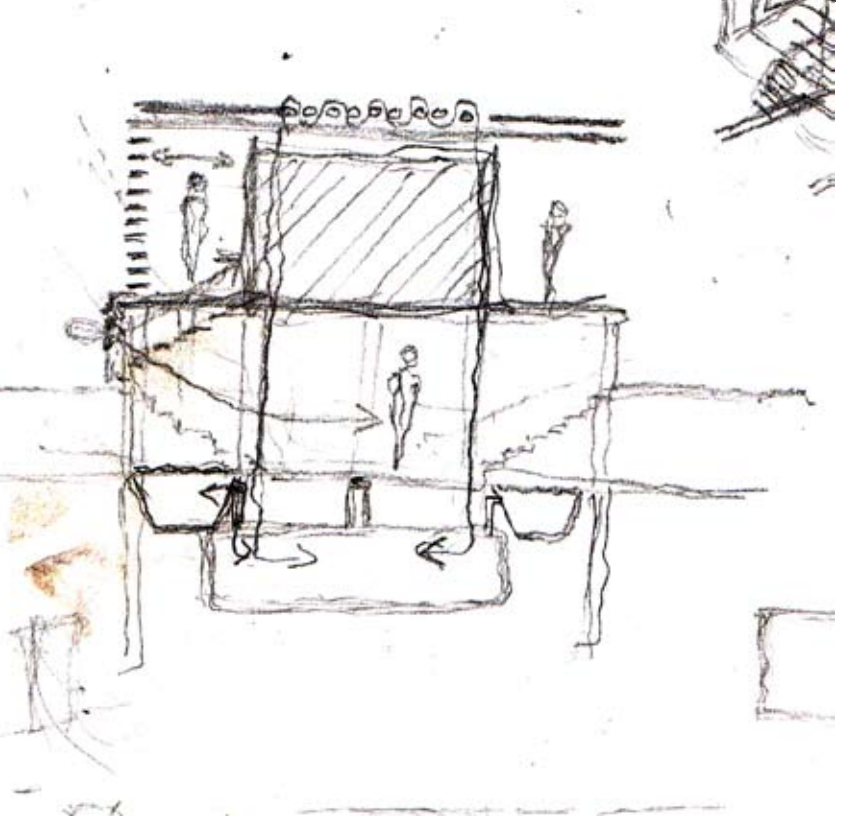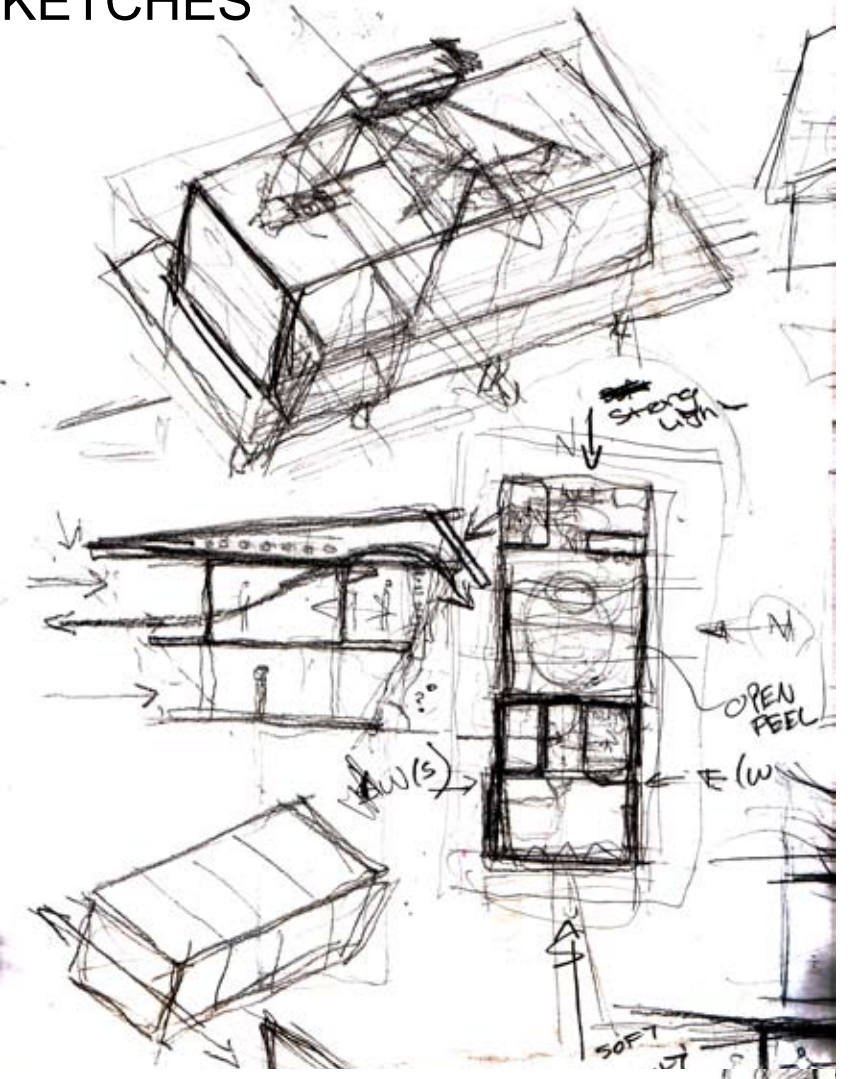

# SUN ANGLES AND DEVELOPING LOUVRE SYSTEMS

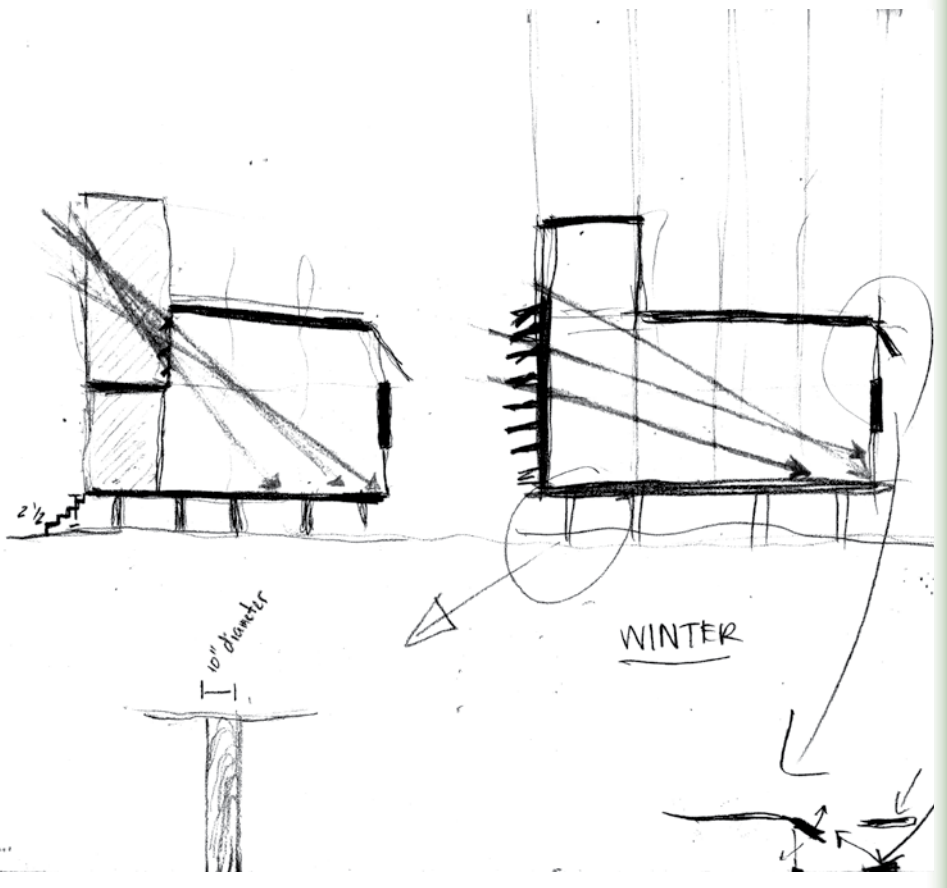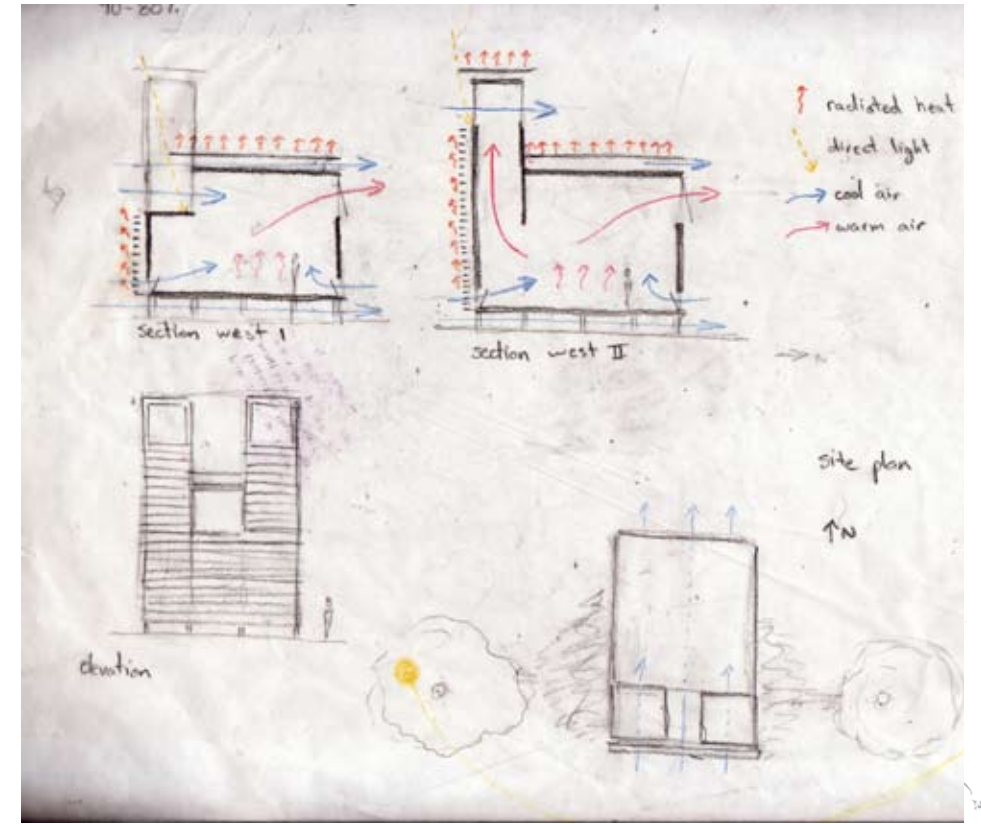

MATERIALS AND ASSEMBLY  
HOT & HUMID  
BRASILIA, BRAZIL

A0.0  
Diagrams & Sketches

FINAL SUBMISSION  
APRIL 23,  
2009

Sara Gotschewski  
Kevin Rodriguez  
Ryan Ralston

SKR  
ARCHITECTS


MATERIALS AND ASSEMBLY  
HOT & HUMID  
BRASILIA, BRAZIL

A1.1  
Floor Plan

FINAL SUBMISSION  
APRIL 23,  
2009

Sara Gotschewski  
Kevin Rodriguez  
Ryan Ralston

SKR  
ARCHITECTS

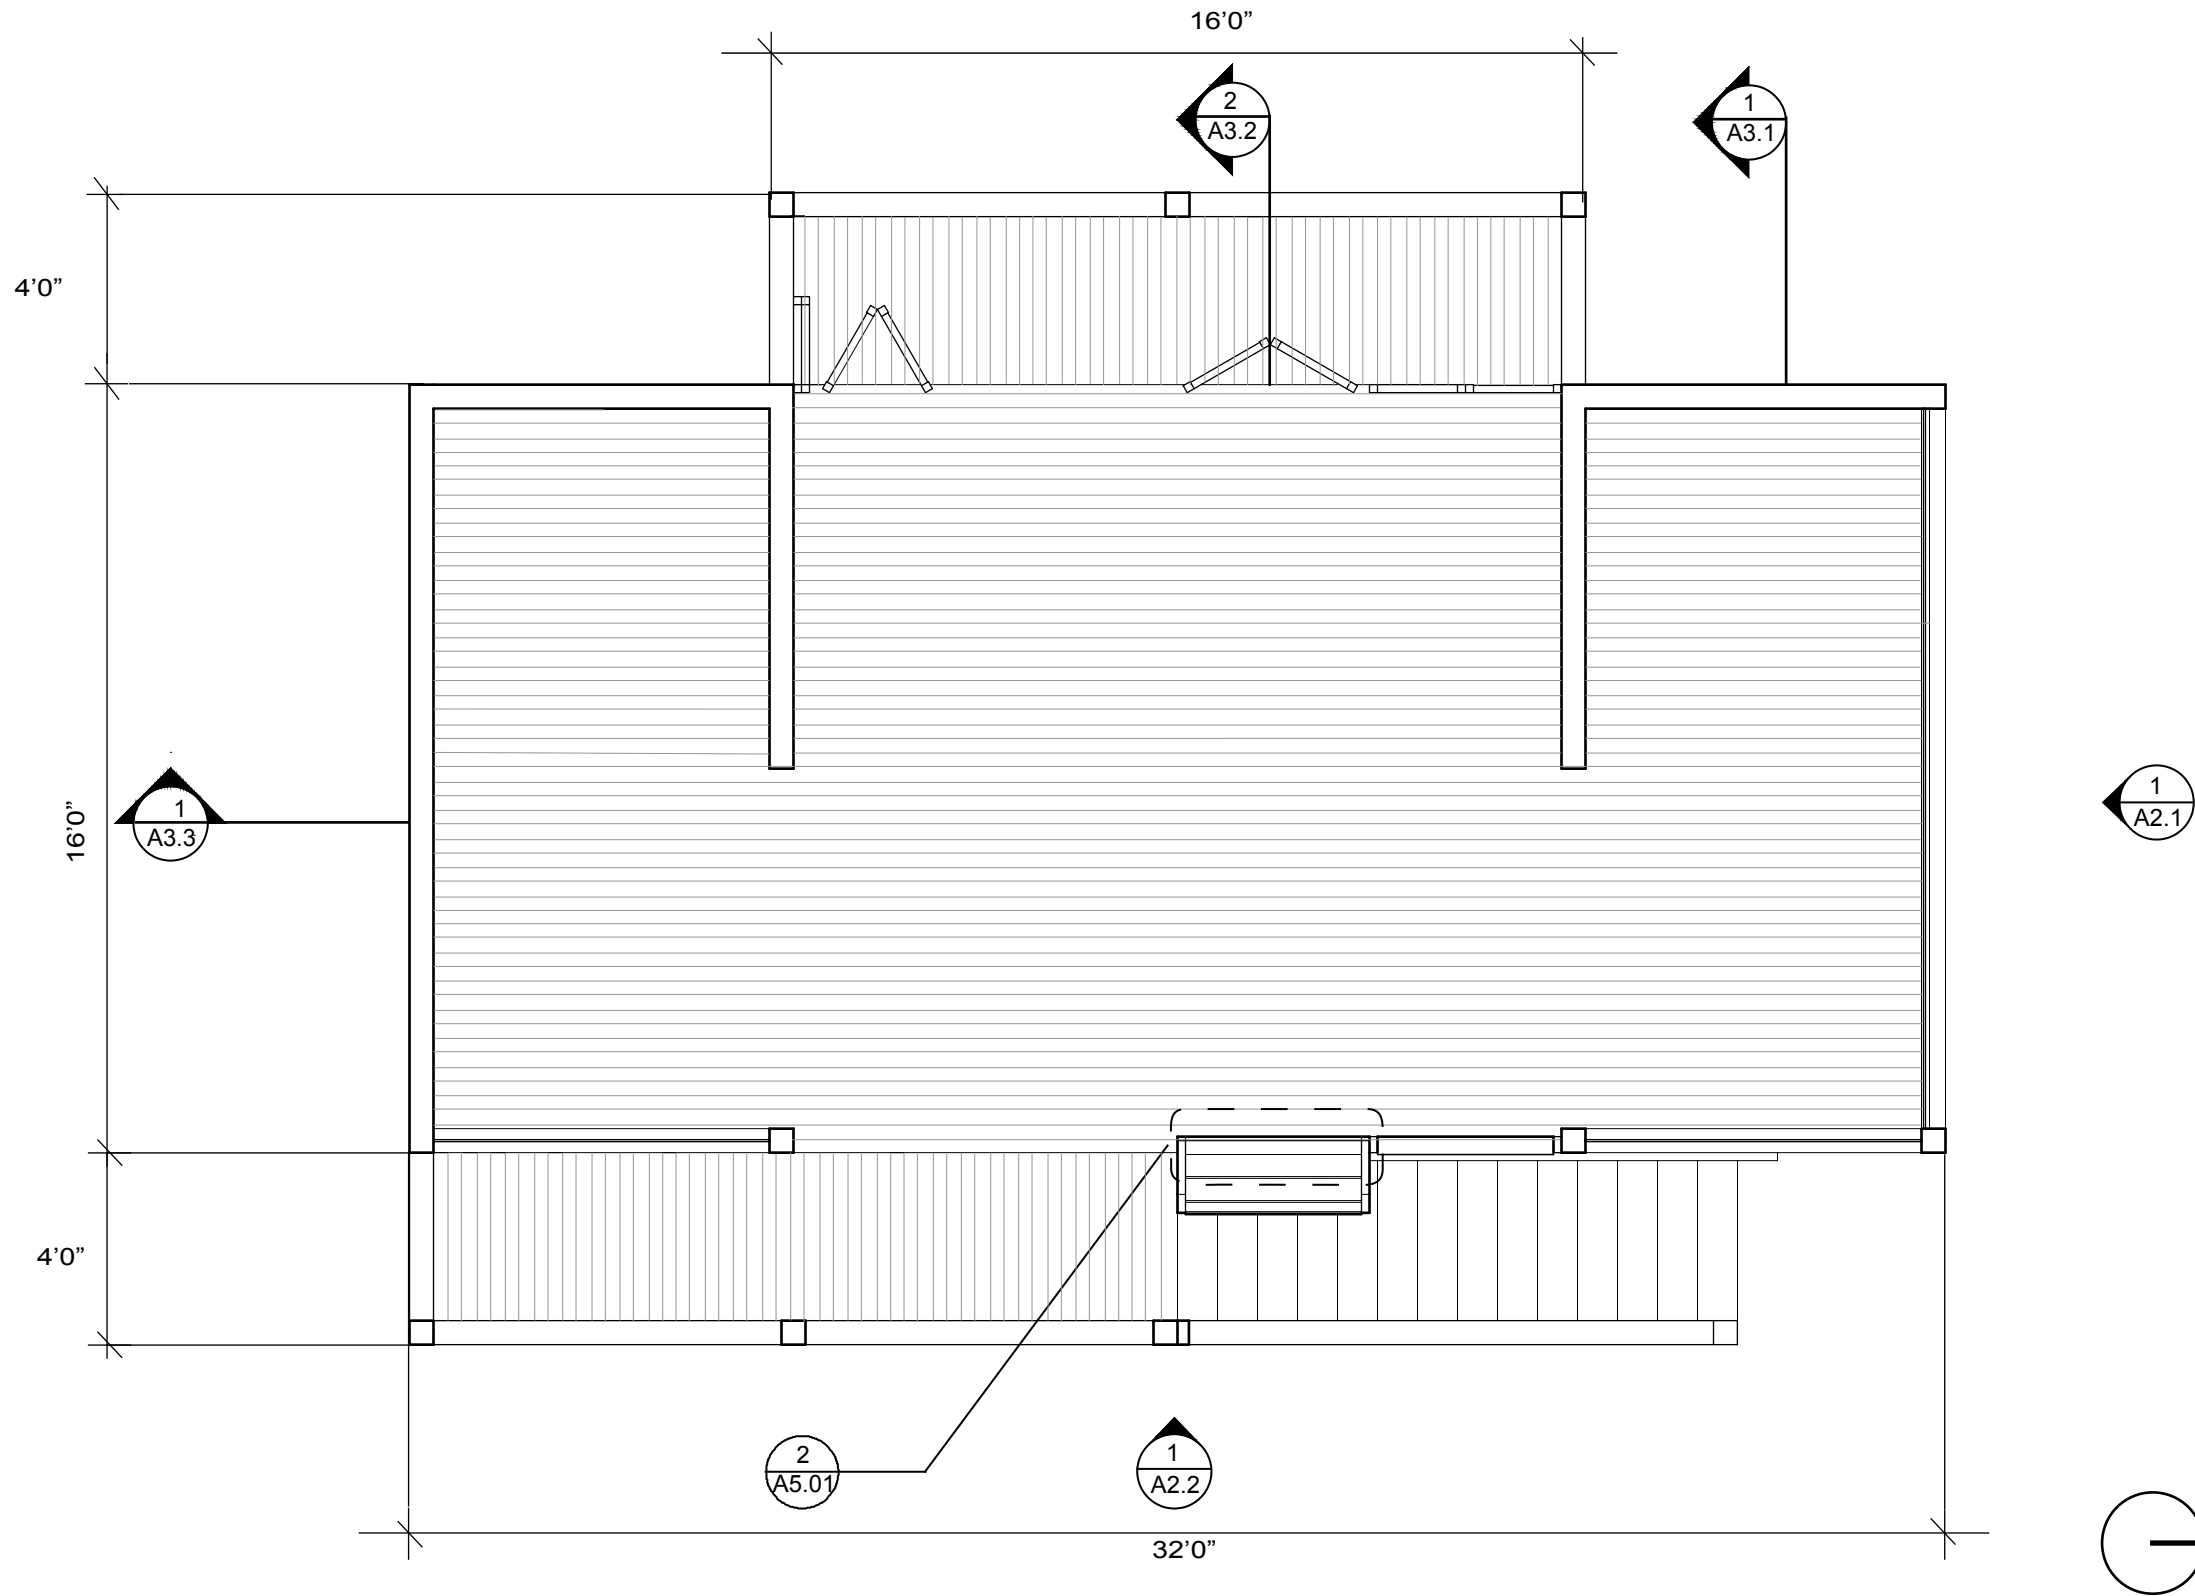

1

PLAN

SCALE 1/4" = 1'

Top of Tower  
22'0"


Ceiling  
19'0"

Top of Railing  
12'2"

Bottom of Balcony  
8'0"

Ground Level  
0'0"

1  
A3.3

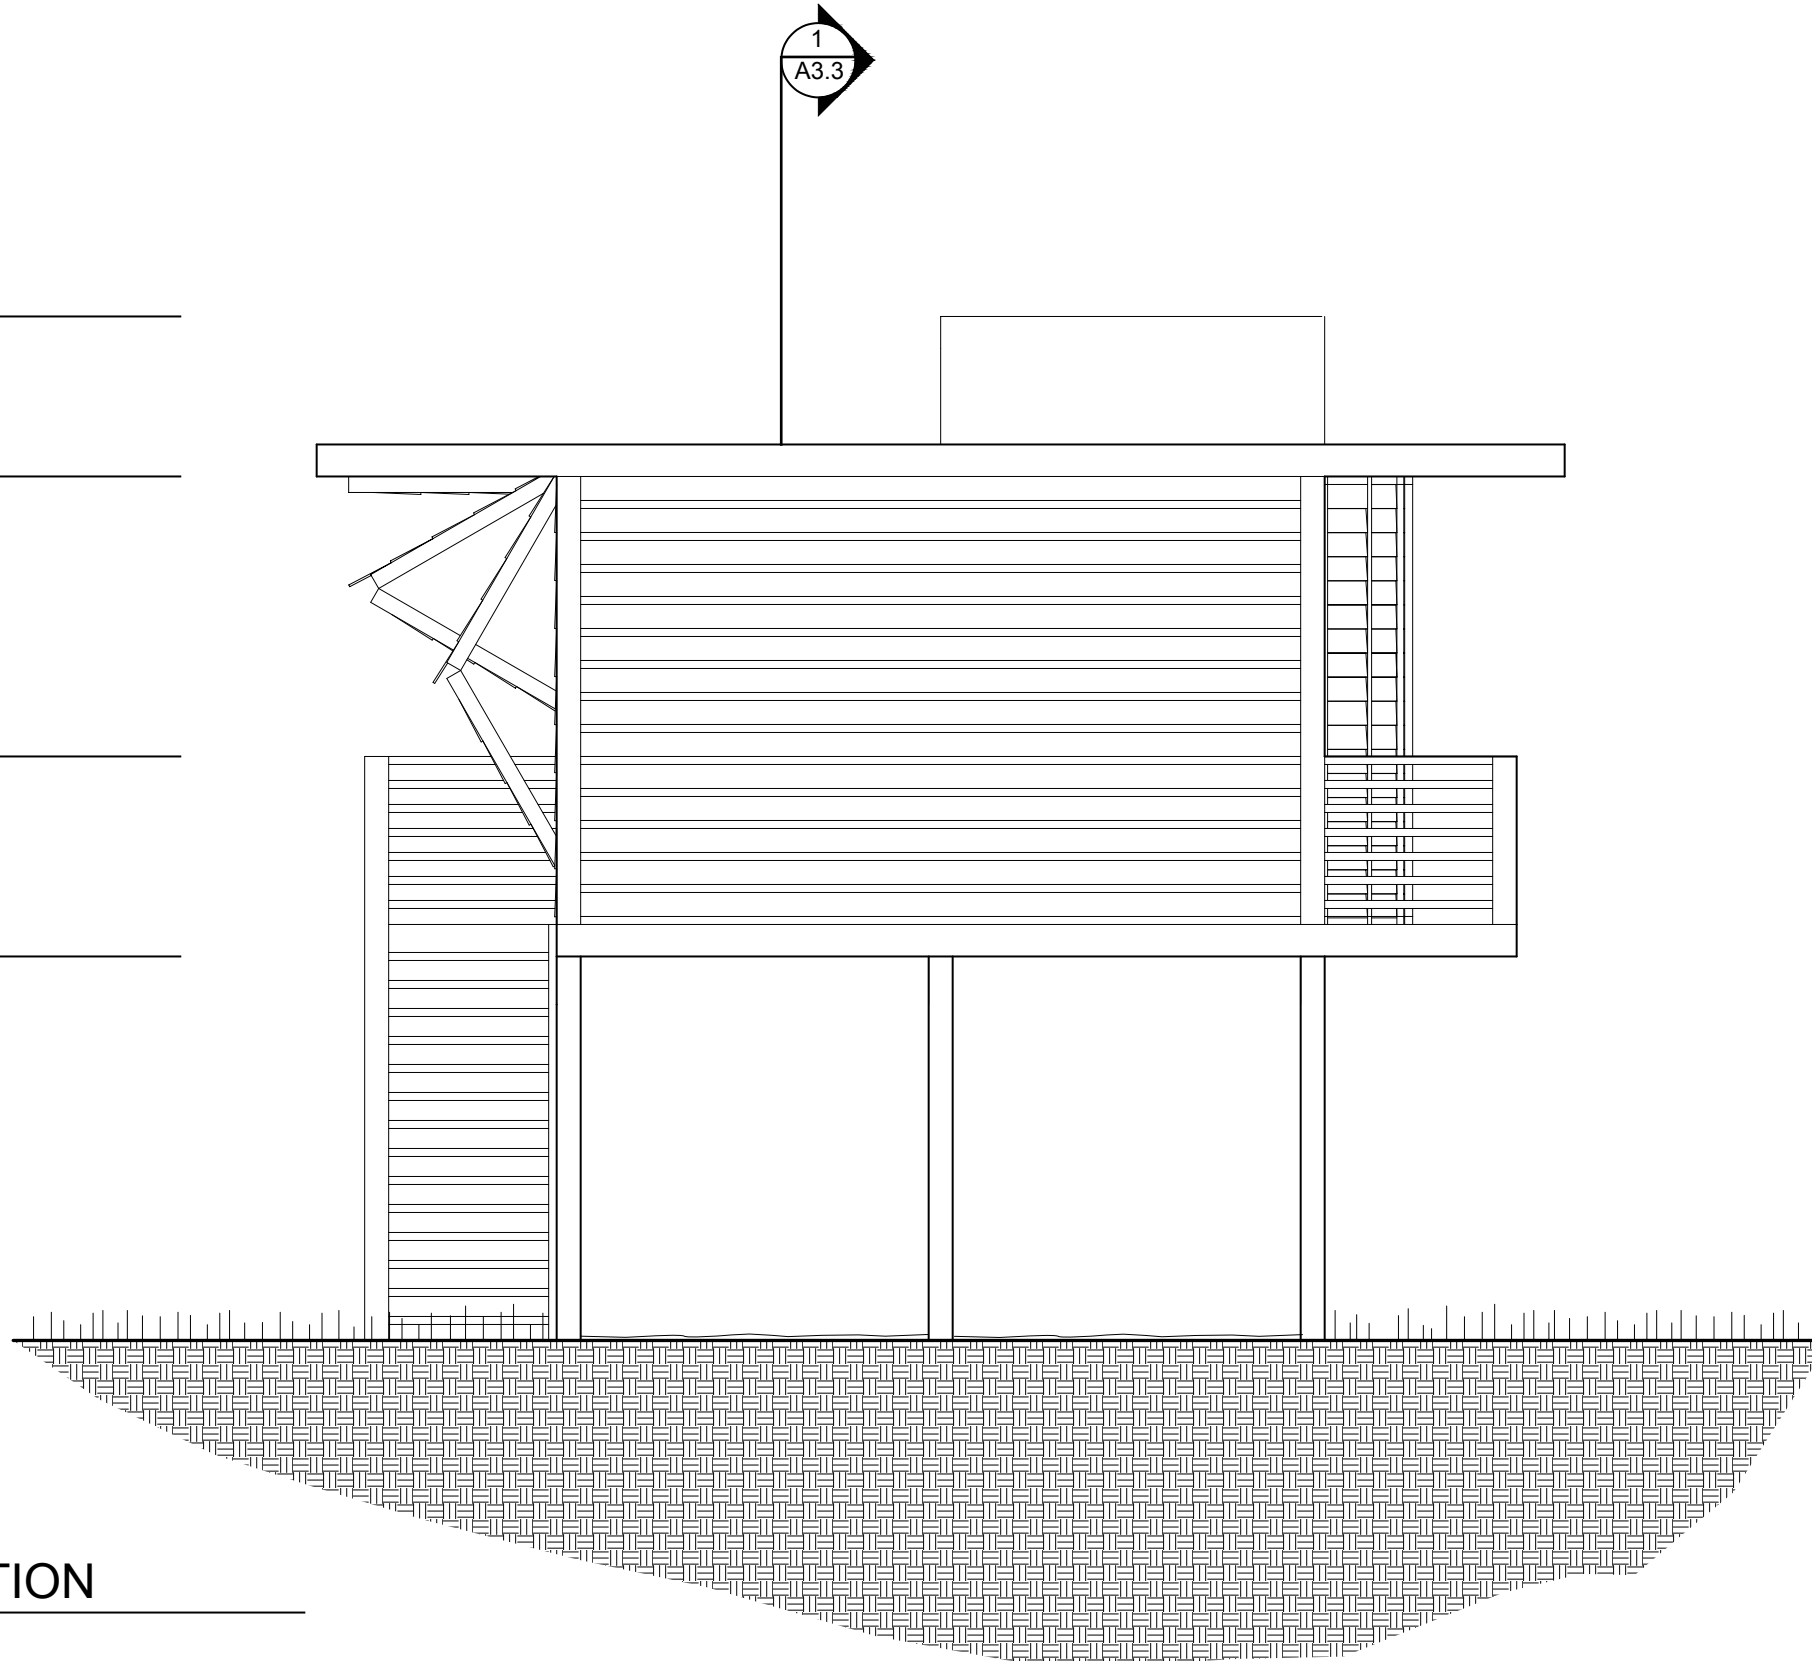

1 SOUTH ELEVATION  
SCALE 1/4" = 1'

MATERIALS AND ASSEMBLY  
HOT & HUMID  
BRASILIA, BRAZIL

A 2.1  
Elevation

FINAL SUBMISSION  
APRIL 23,  
2009

Sara Gotschewski  
Kevin Rodriguez  
Ryan Ralston

SKR  
ARCHITECTS


MATERIALS AND ASSEMBLY  
HOT & HUMID  
BRASILIA, BRAZIL

A2.2  
Elevation

FINAL SUBMISSION  
APRIL 23,  
2009



Sara Gotschewski  
Kevin Rodriguez  
Ryan Ralston

SKR  
ARCHITECTS

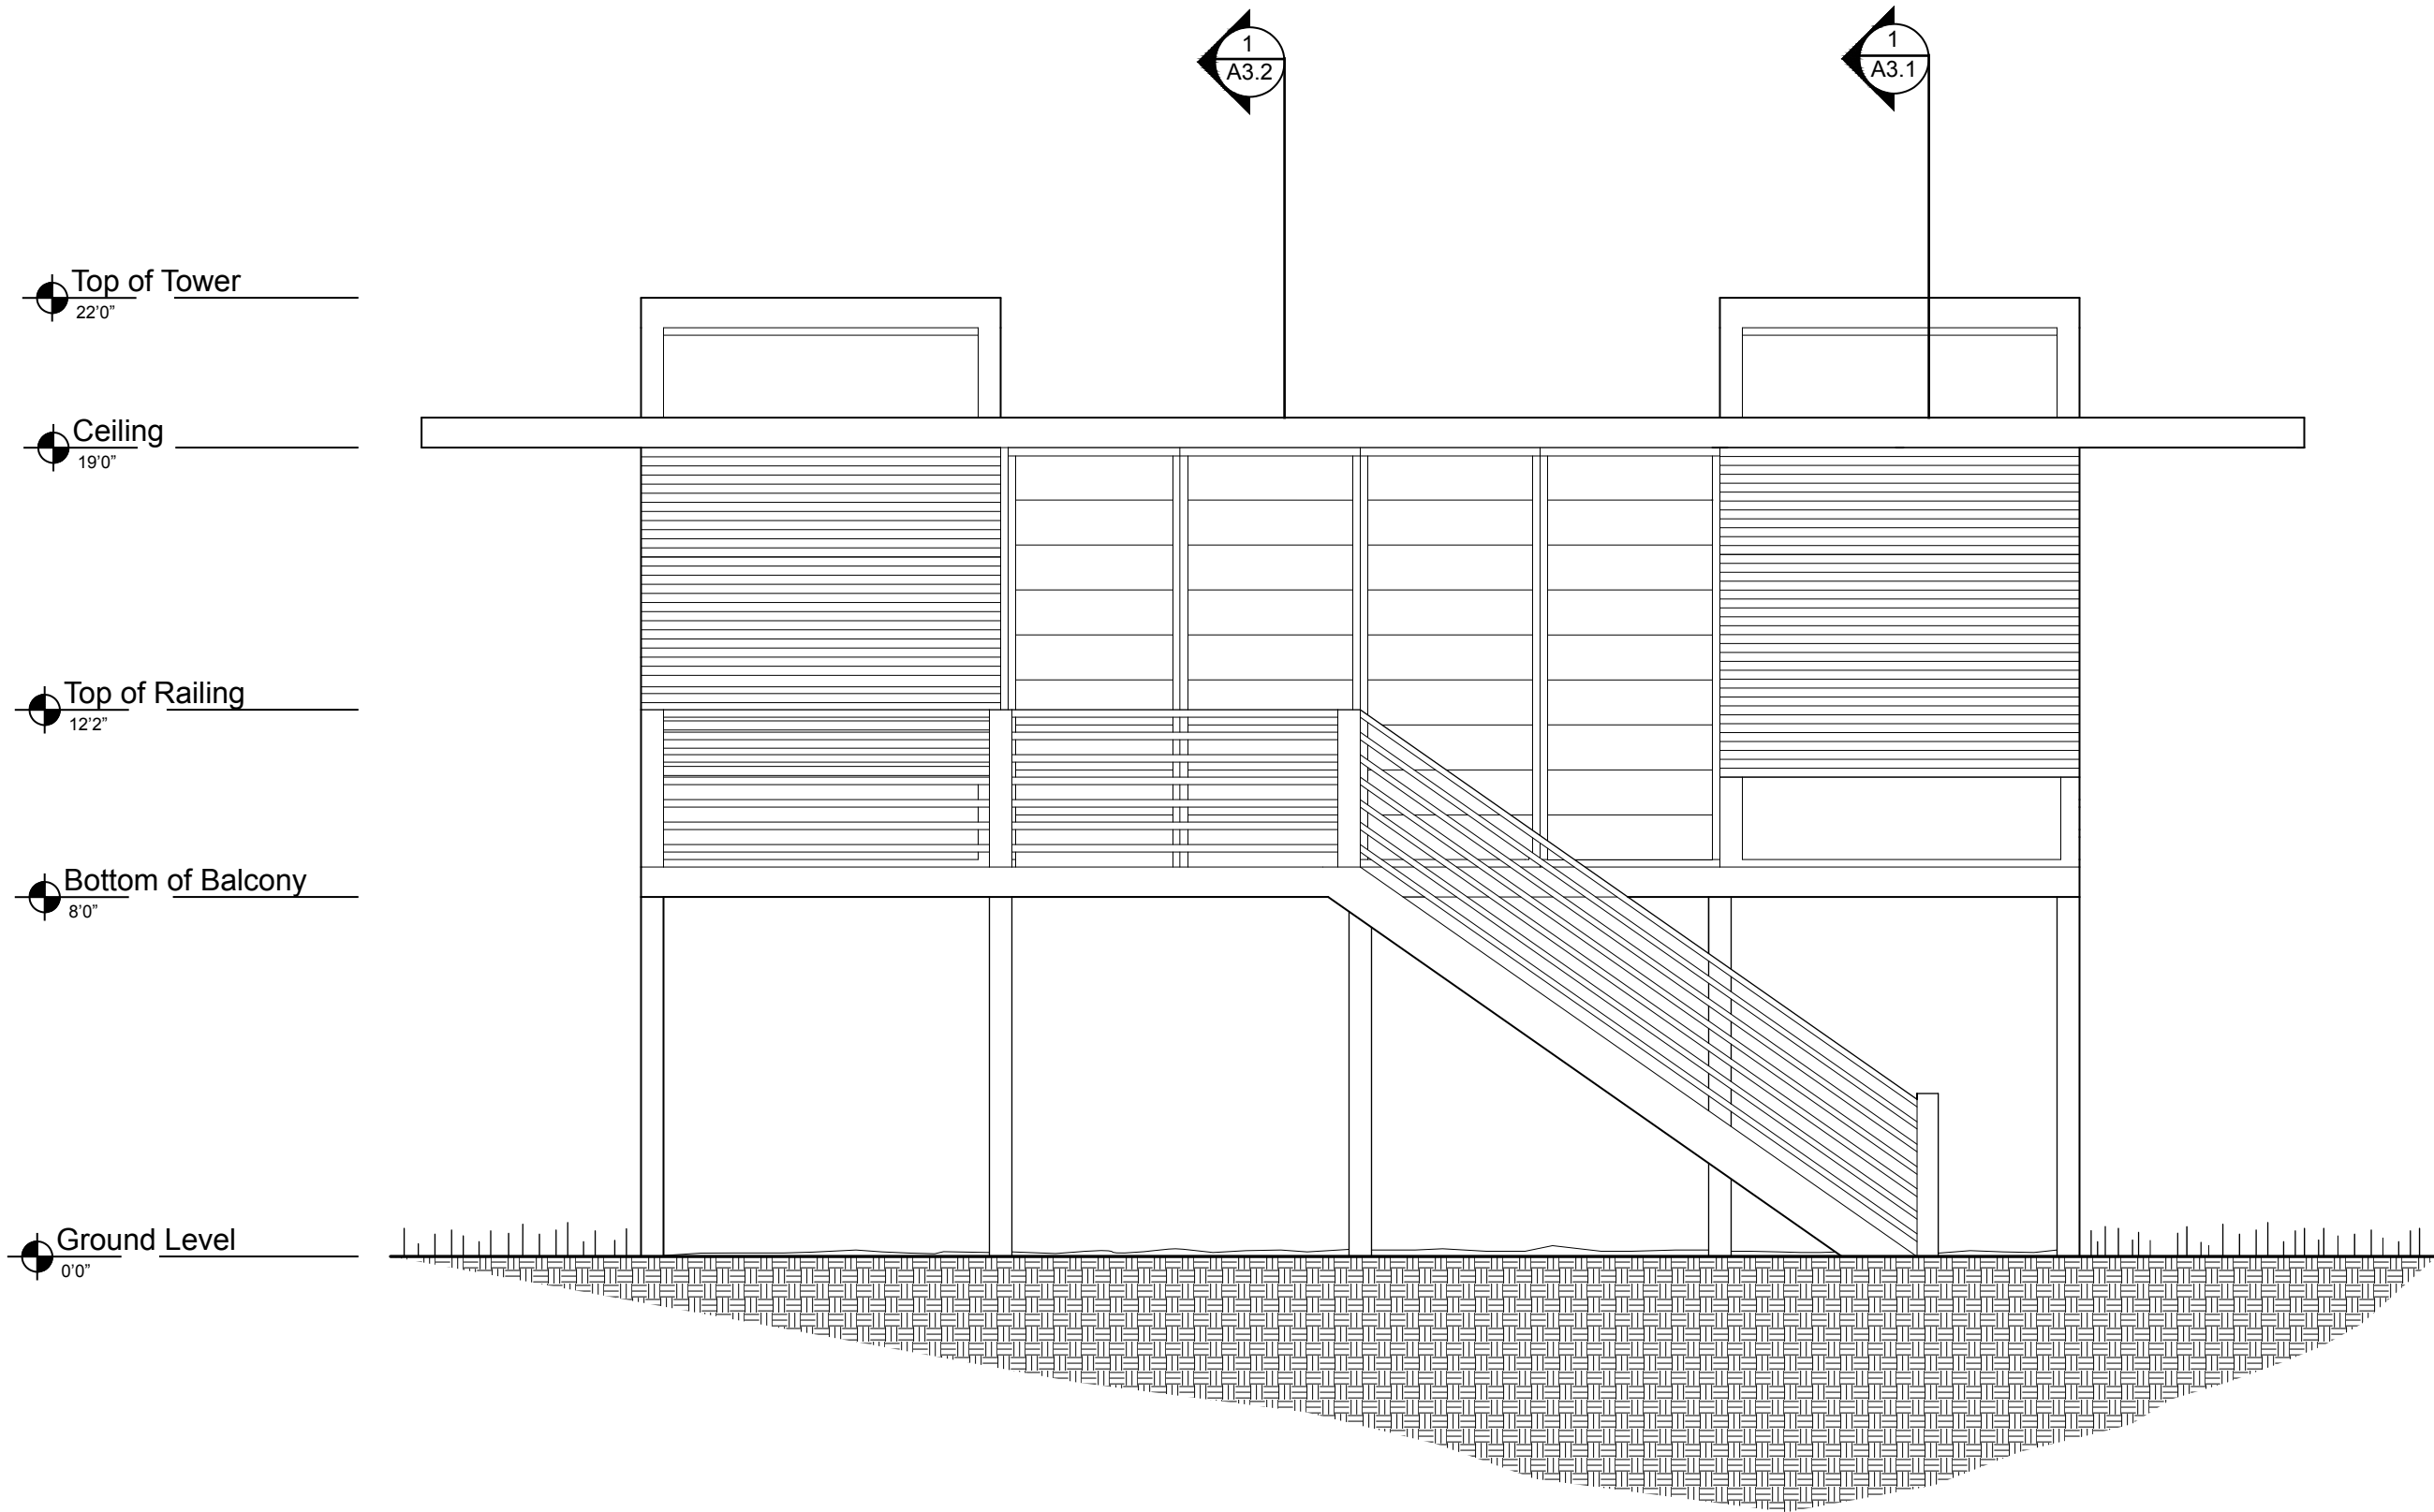

1 EAST ELEVATION  
SCALE 1/4" = 1'



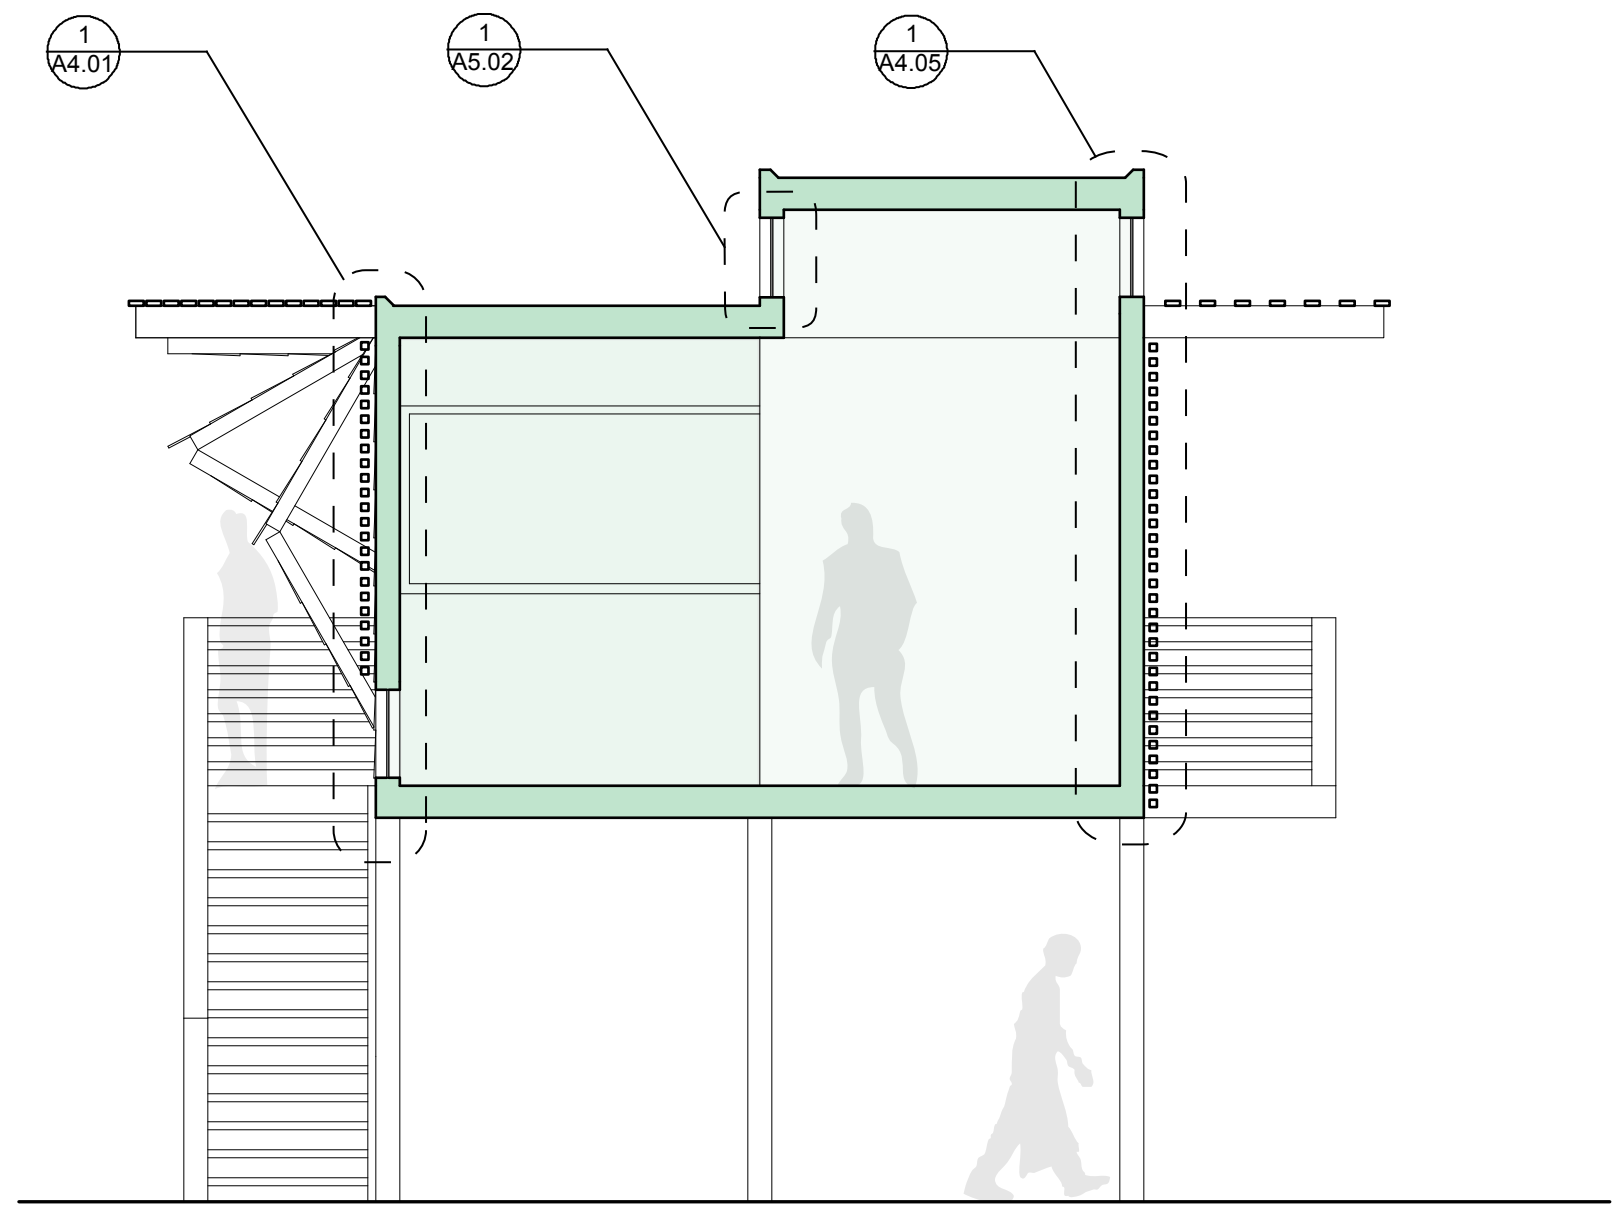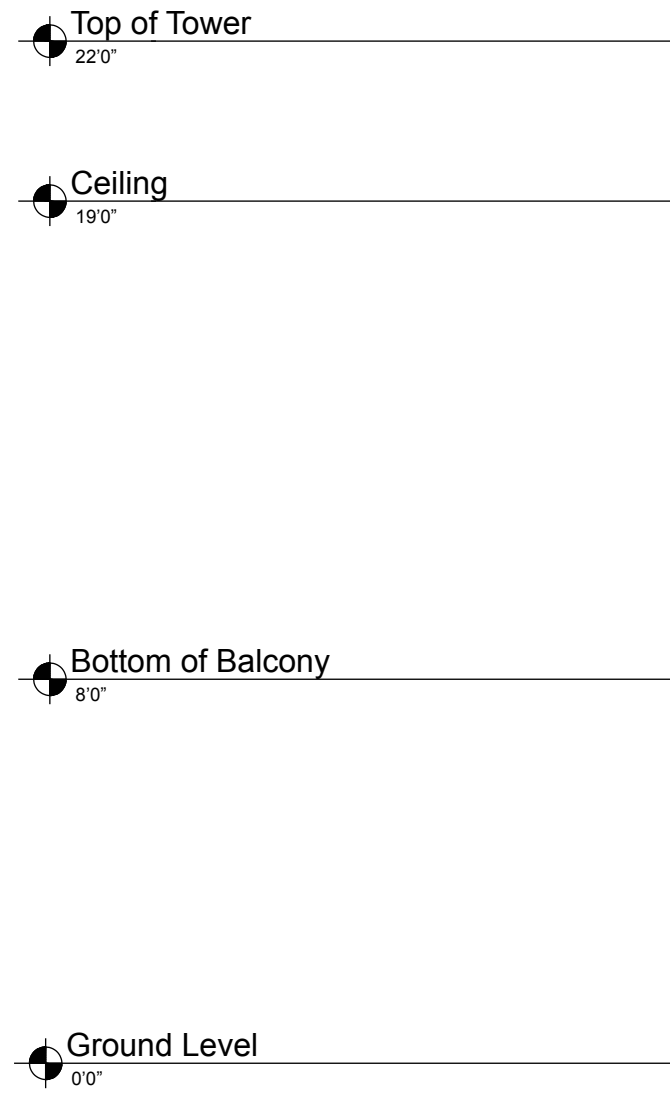

1 TRANSVERSE SECTION 1  
SCALE 1/4" = 1'

MATERIALS AND ASSEMBLY  
HOT & HUMID  
BRASILIA, BRAZIL

A3.1  
Transverse Section


FINAL SUBMISSION  
APRIL 23,  
2009

Sara Gotschewski

Kevin Rodriguez

Ryan Ralston



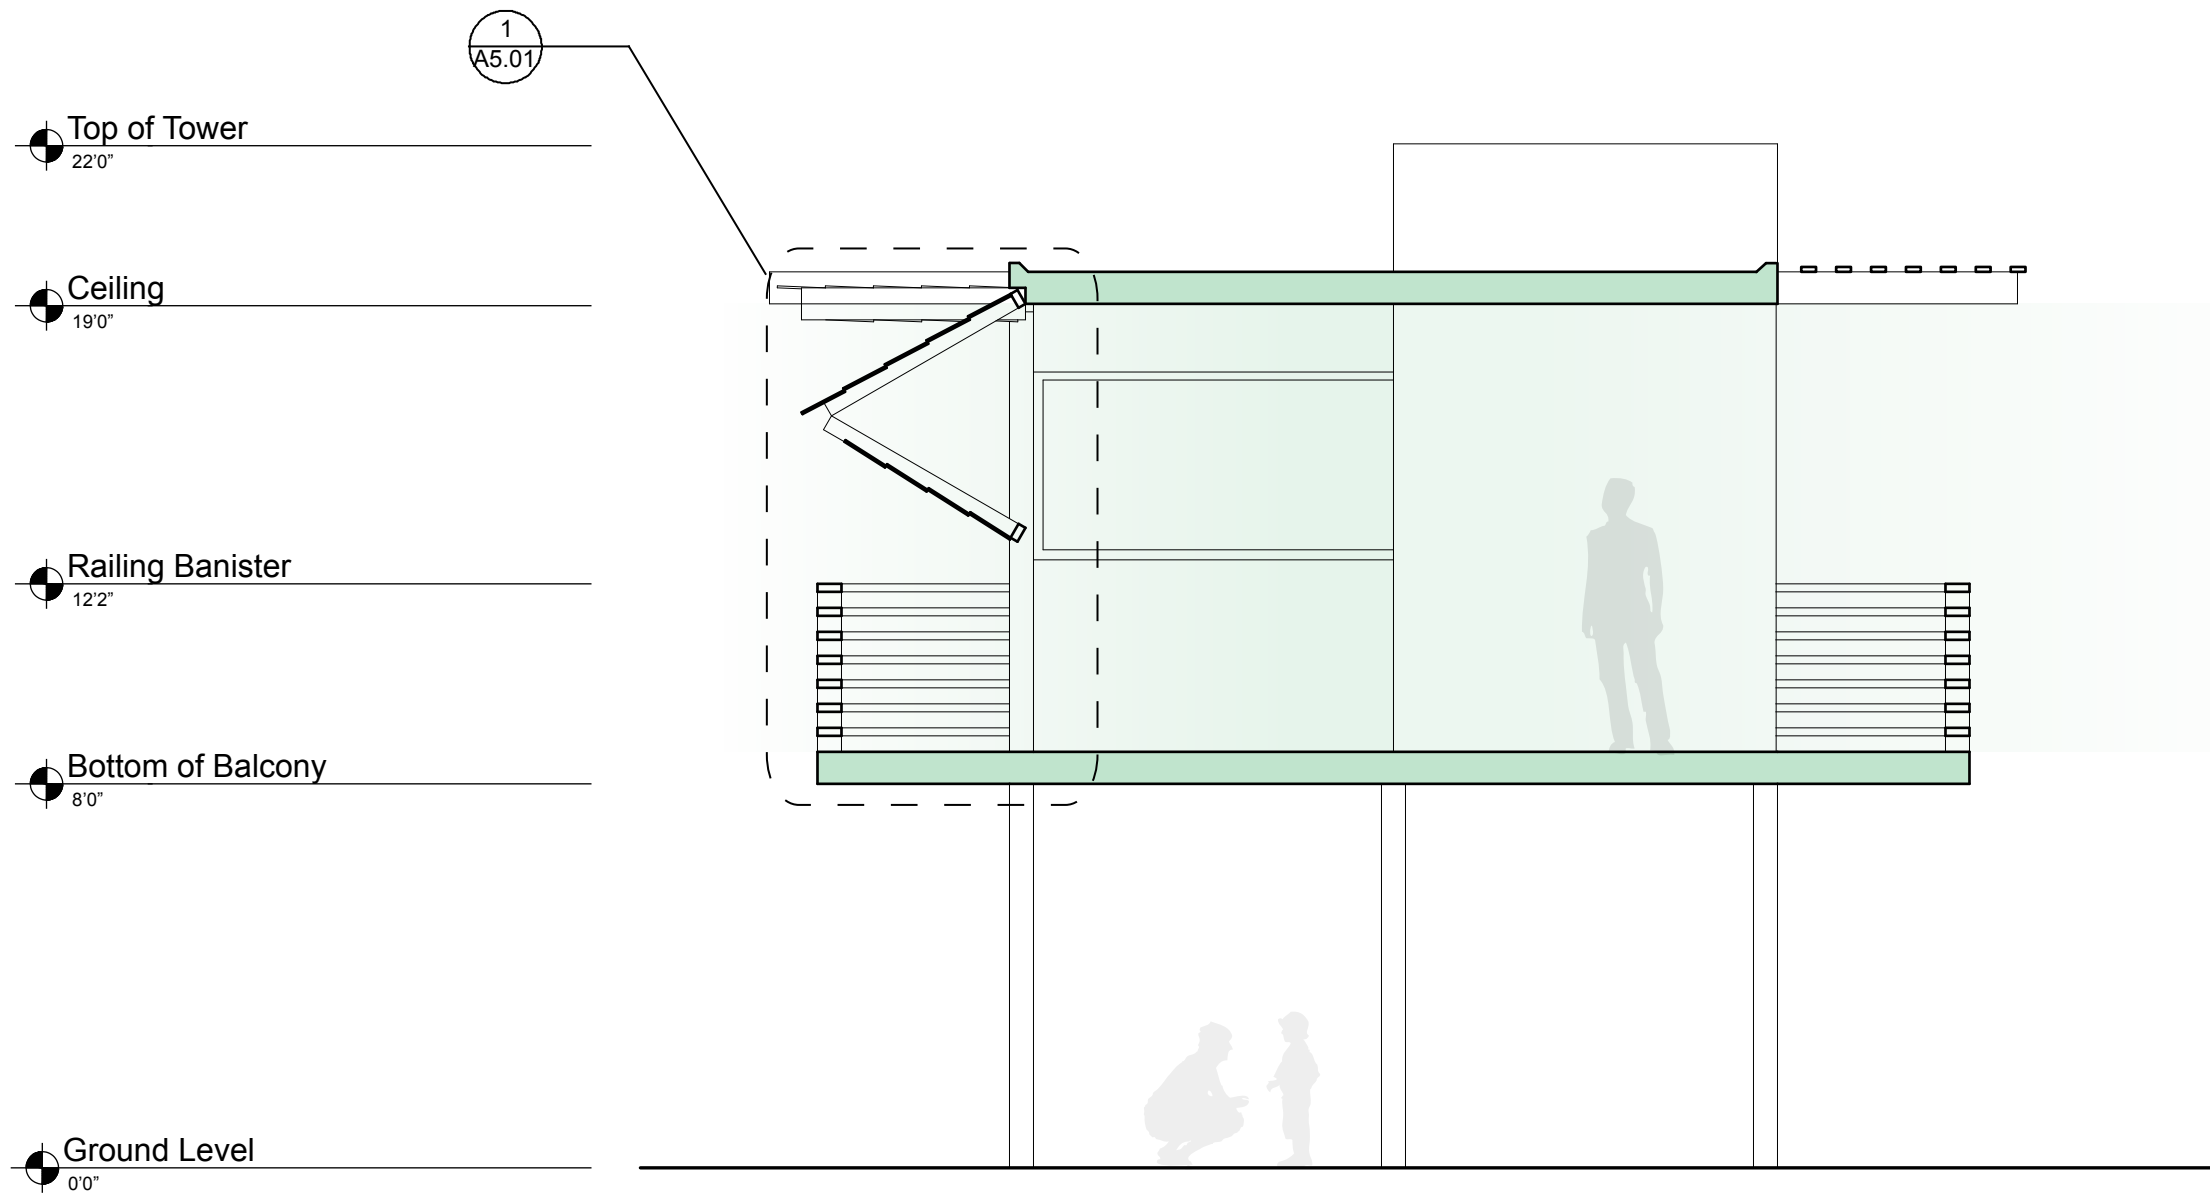

1

**TRANSVERSE SECTION 2**

SCALE 1/4" = 1'

**MATERIALS AND ASSEMBLY  
HOT & HUMID  
BRASILIA, BRAZIL**

**A3.2**  
Transverse Section


FINAL SUBMISSION  
APRIL 23,  
2009

Sara Gotschewski

Kevin Rodriguez

Ryan Ralston

**SKR**  
ARCHITECTS

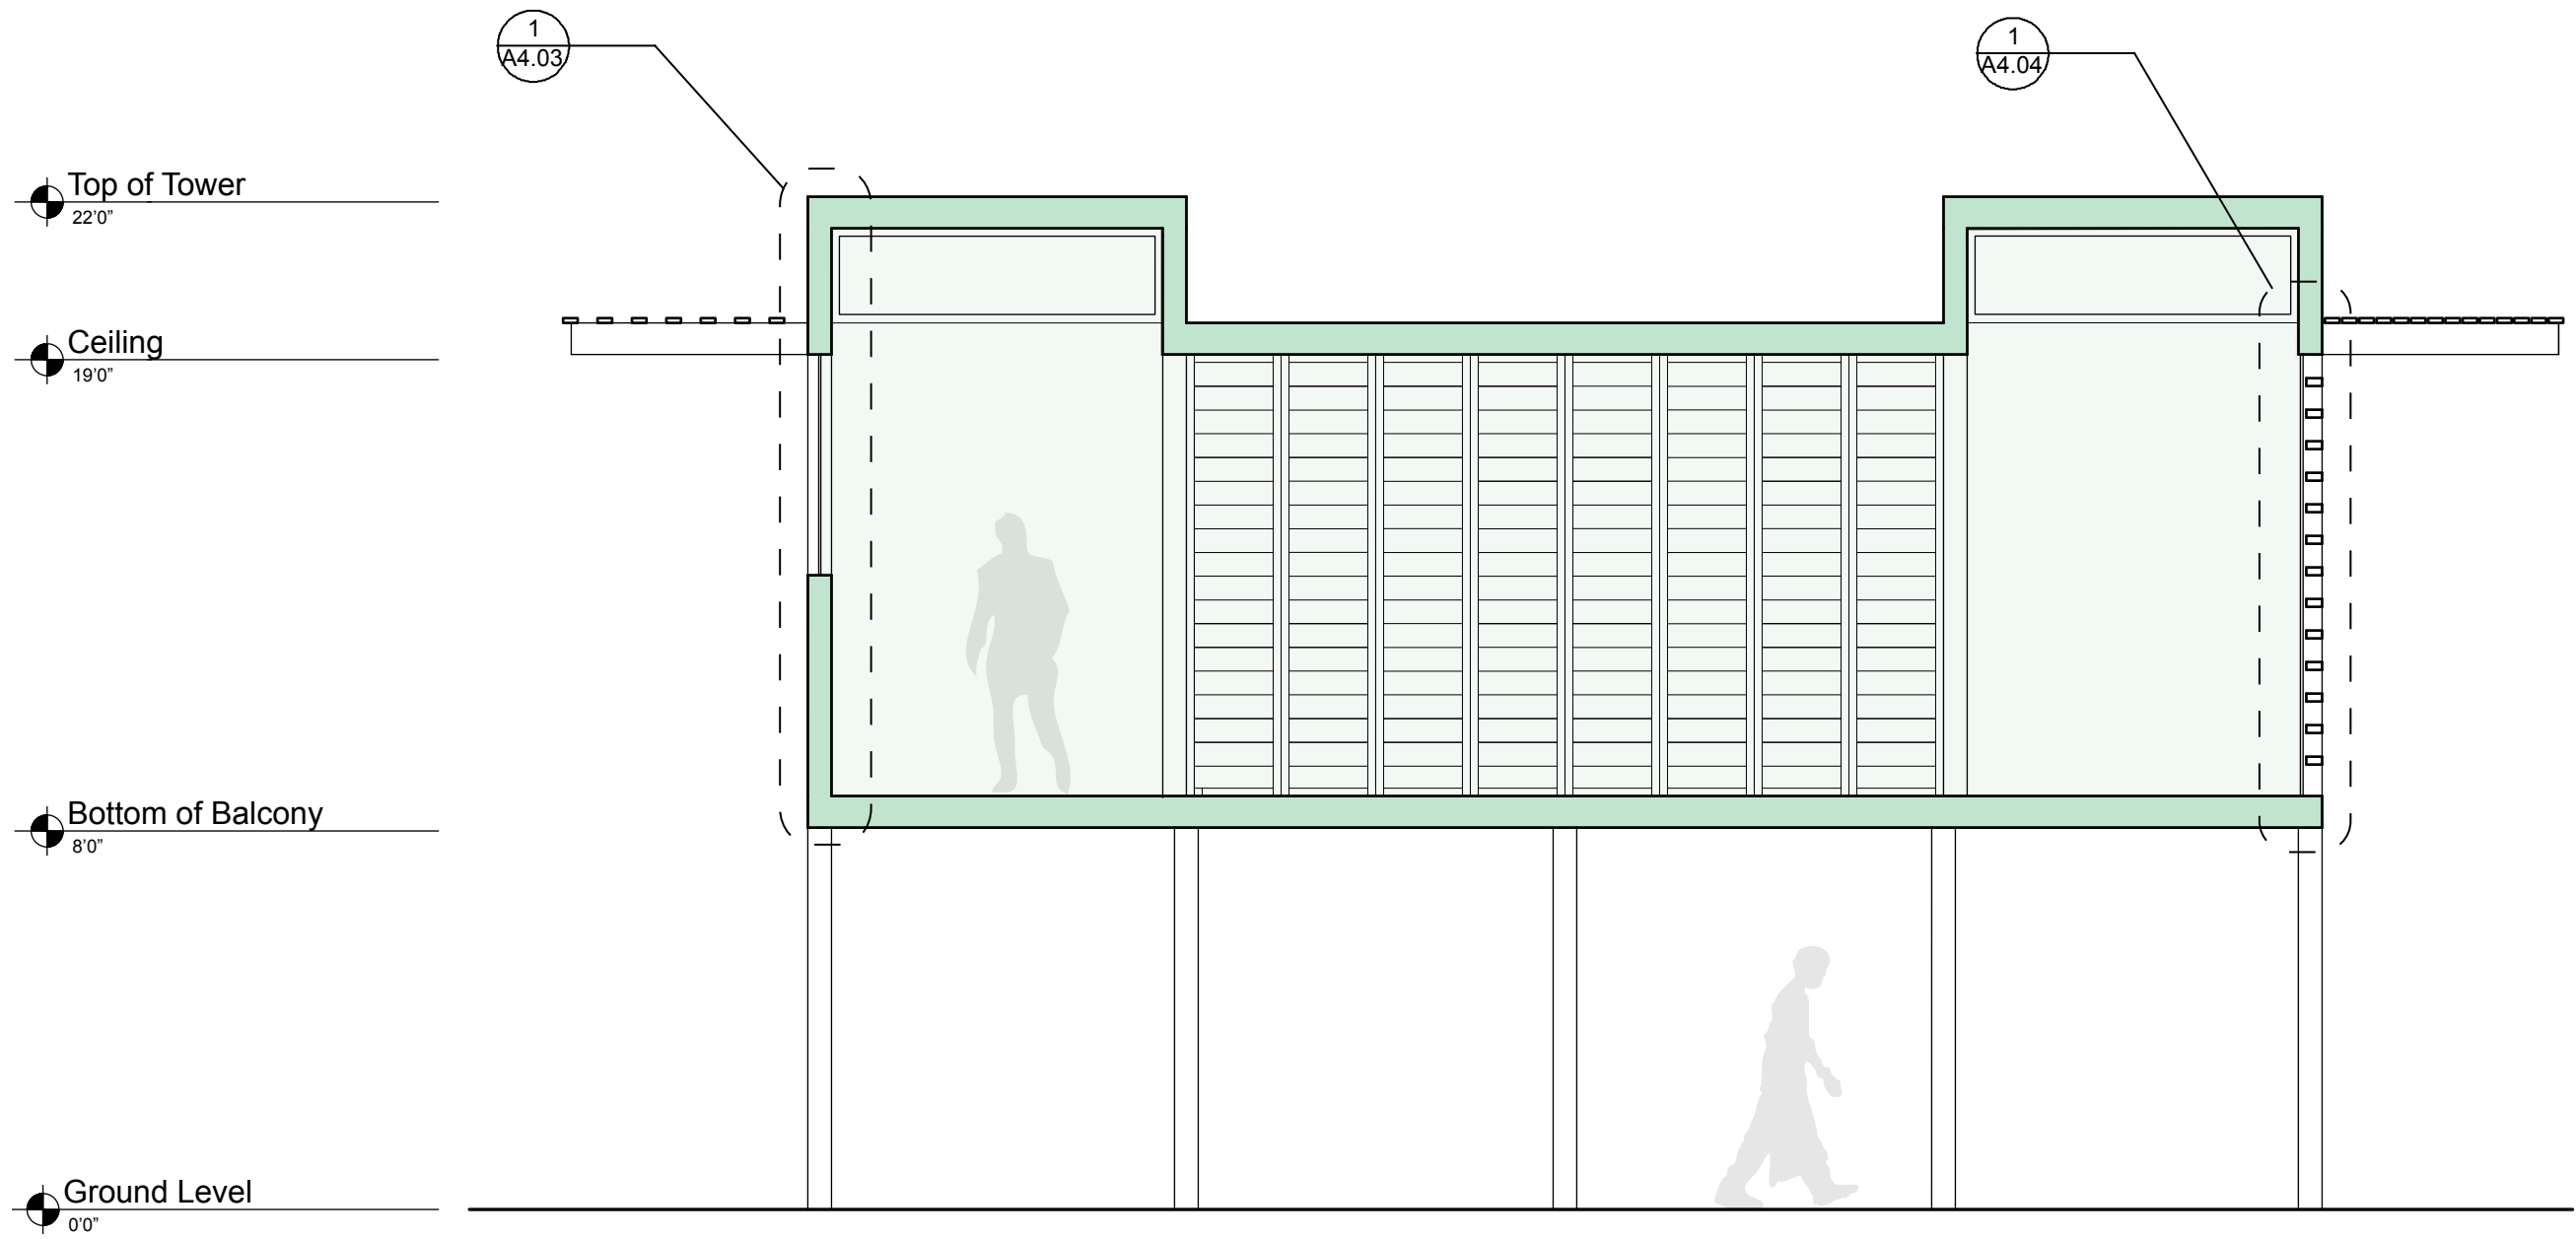


MATERIALS AND ASSEMBLY  
 HOT & HUMID  
 BRASILIA, BRAZIL

**A3.3**  
 Longitudinal Section

FINAL SUBMISSION  
 APRIL 23,  
 2009

Sara Gotschewski  
 Kevin Rodriguez  
 Ryan Ralston



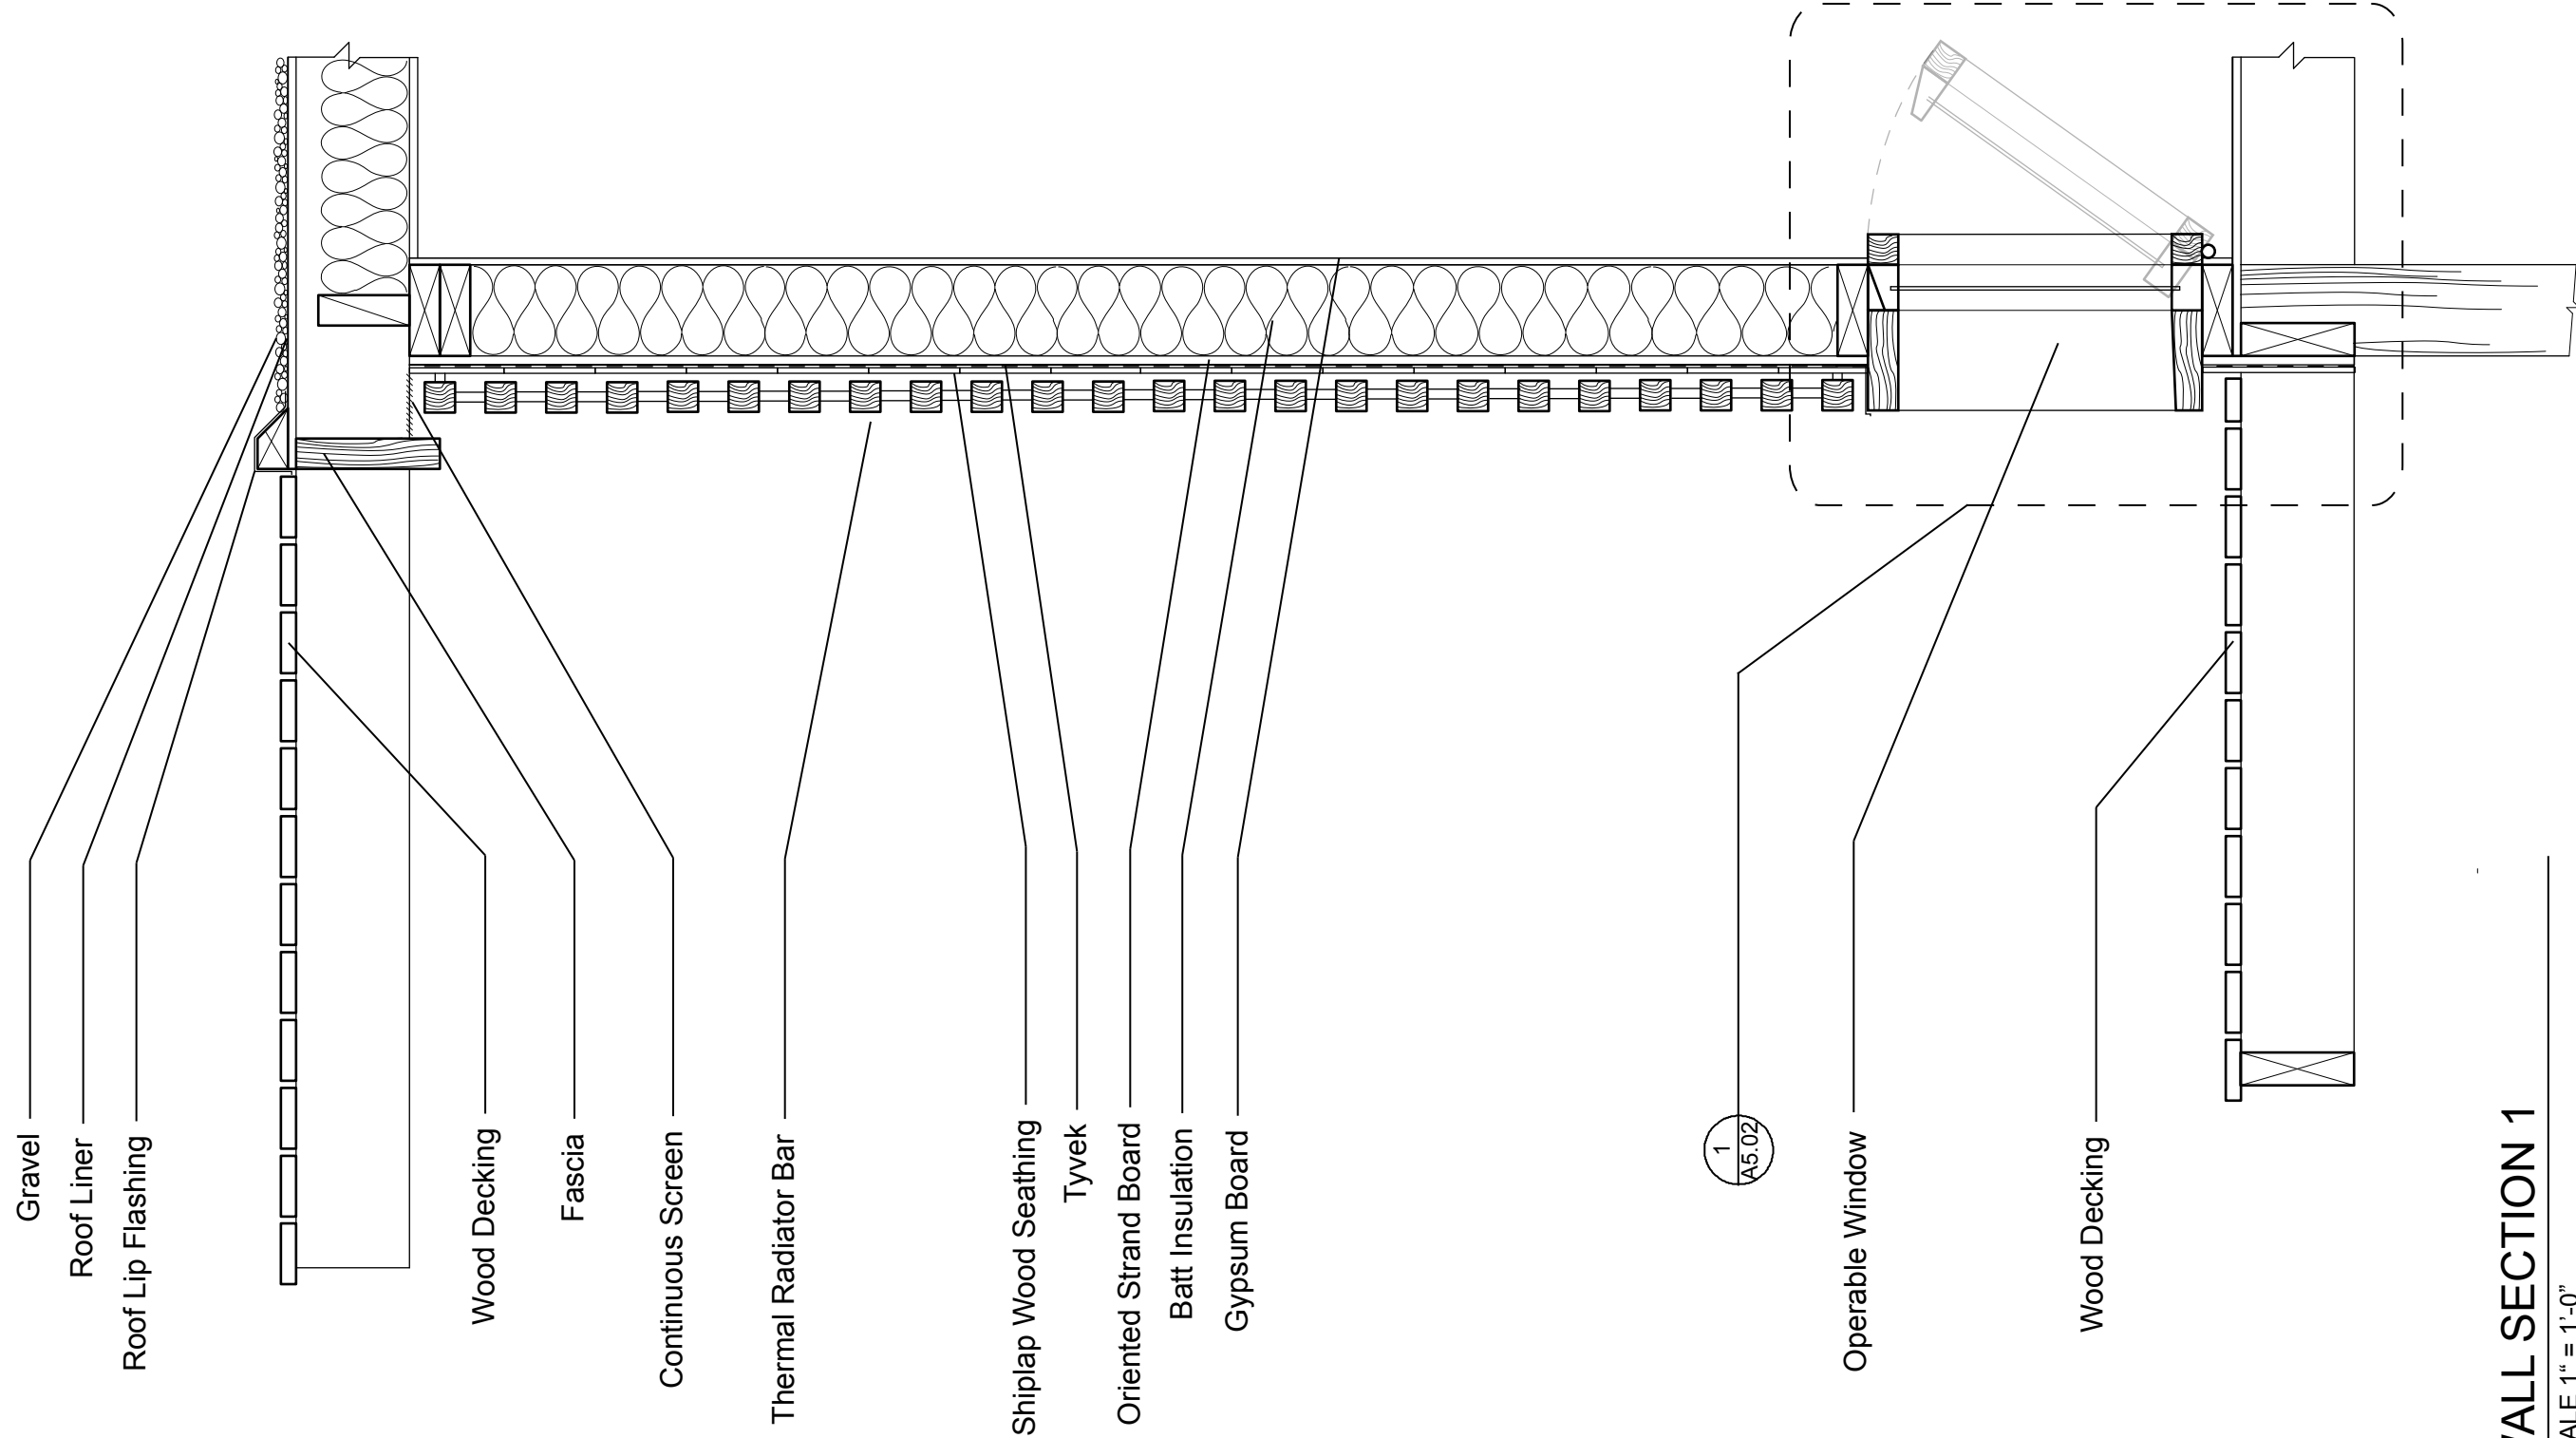

Gravel

Roof Liner

Roof Lip Flashing

Wood Decking

Fascia

Continuous Screen

Thermal Radiator Bar

Shiplap Wood Seathing

Tyvek

Oriented Strand Board

Batt Insulation

Gypsum Board

1  
A5.02

Operable Window

Wood Decking

1 WALL SECTION 1

SCALE 1" = 1'-0"

MATERIALS AND ASSEMBLY  
HOT & HUMID  
BRASILIA, BRAZIL

A4.01  
Wall Section


FINAL SUBMISSION  
APRIL 23,  
2009

Sara Gotschewski

Kevin Rodriguez

Ryan Ralston

SKR  
ARCHITECTS

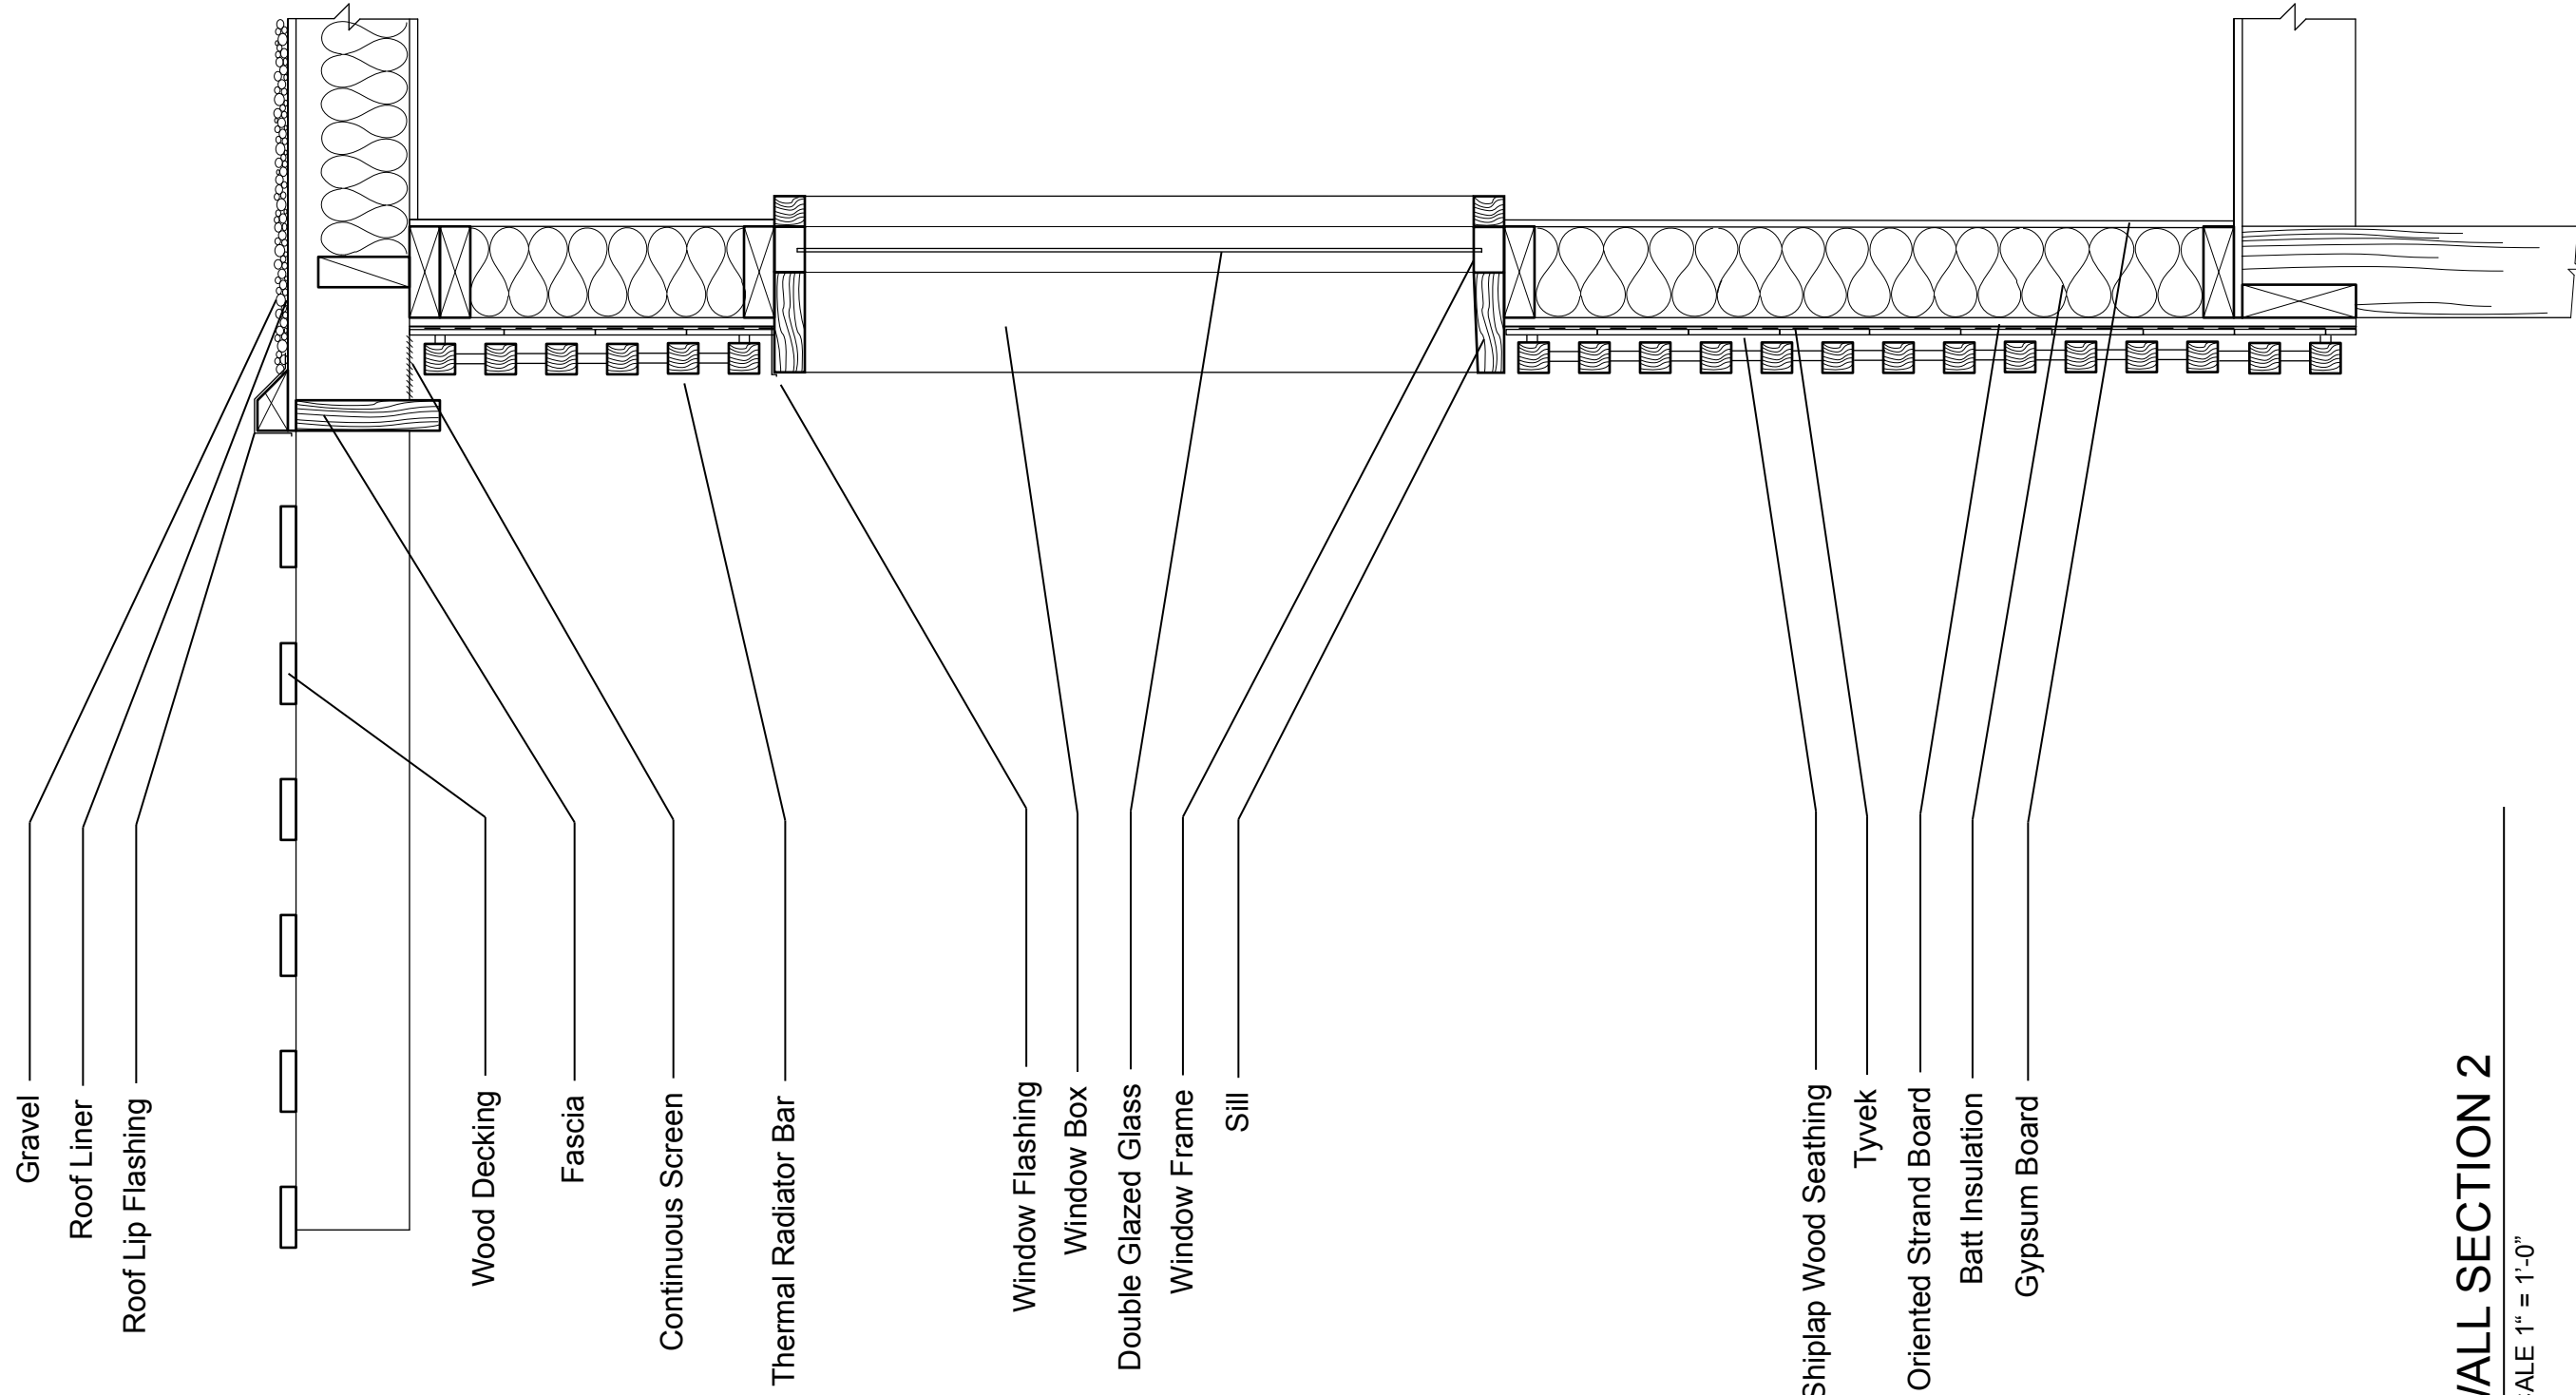

Gravel  
 Roof Liner  
 Roof Lip Flashing

Wood Decking  
 Fascia

Continuous Screen  
 Thermal Radiator Bar

Window Flashing  
 Window Box  
 Double Glazed Glass  
 Window Frame  
 Sill

Shiplap Wood Seathing  
 Tyvek  
 Oriented Strand Board  
 Batt Insulation  
 Gypsum Board

1 WALL SECTION 2

SCALE 1" = 1'-0"


MATERIALS AND ASSEMBLY  
 HOT & HUMID  
 BRASILIA, BRAZIL

A 4.02  
 Wall Section

FINAL SUBMISSION  
 APRIL 23,  
 2009

S Sara Gotschewski  
 K Kevin Rodriguez  
 R Ryan Ralston

**SKR**  
 ARCHITECTS

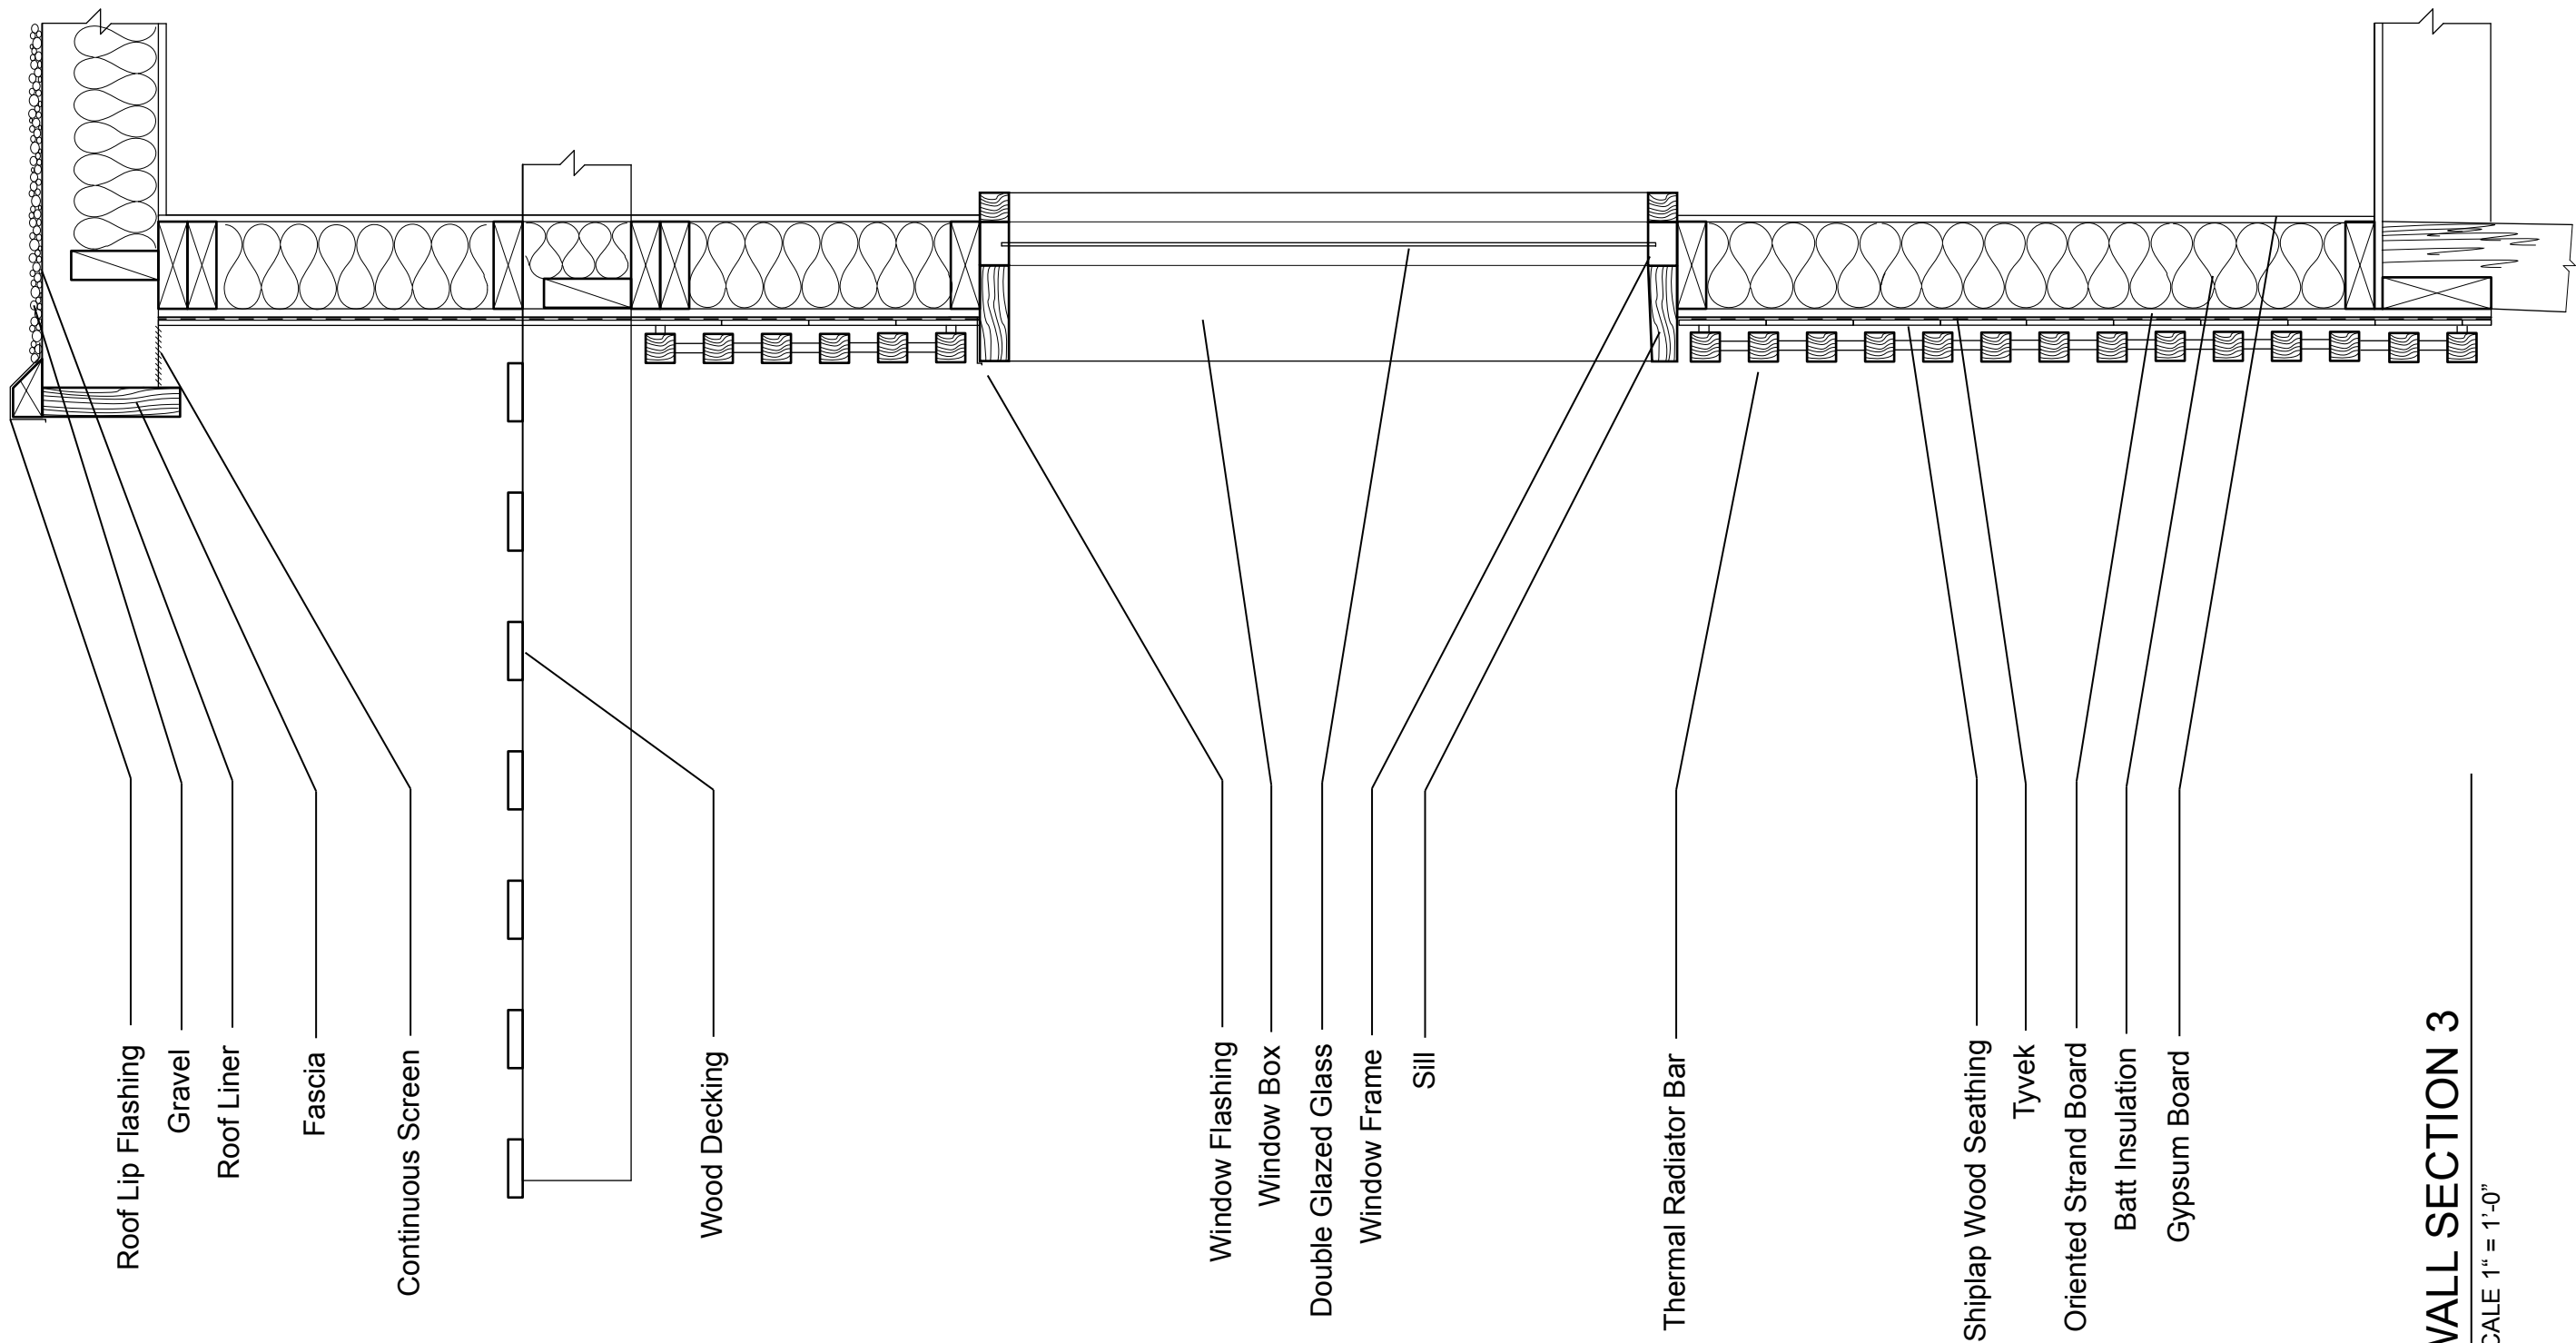

Roof Lip Flashing

Gravel

Roof Liner

Fascia

Continuous Screen

Wood Decking

Window Flashing

Window Box

Double Glazed Glass

Window Frame

Sill

Thermal Radiator Bar

Shiplap Wood Seathing

Tyvek

Oriented Strand Board

Batt Insulation

Gypsum Board

1 WALL SECTION 3

SCALE 1" = 1'-0"

MATERIALS AND ASSEMBLY  
HOT & HUMID  
BRASILIA, BRAZIL

A4.03  
Wall Section


FINAL SUBMISSION  
APRIL 23,  
2009

Sara Gotschewski

Kevin Rodriguez

Ryan Ralston

SKR  
ARCHITECTS

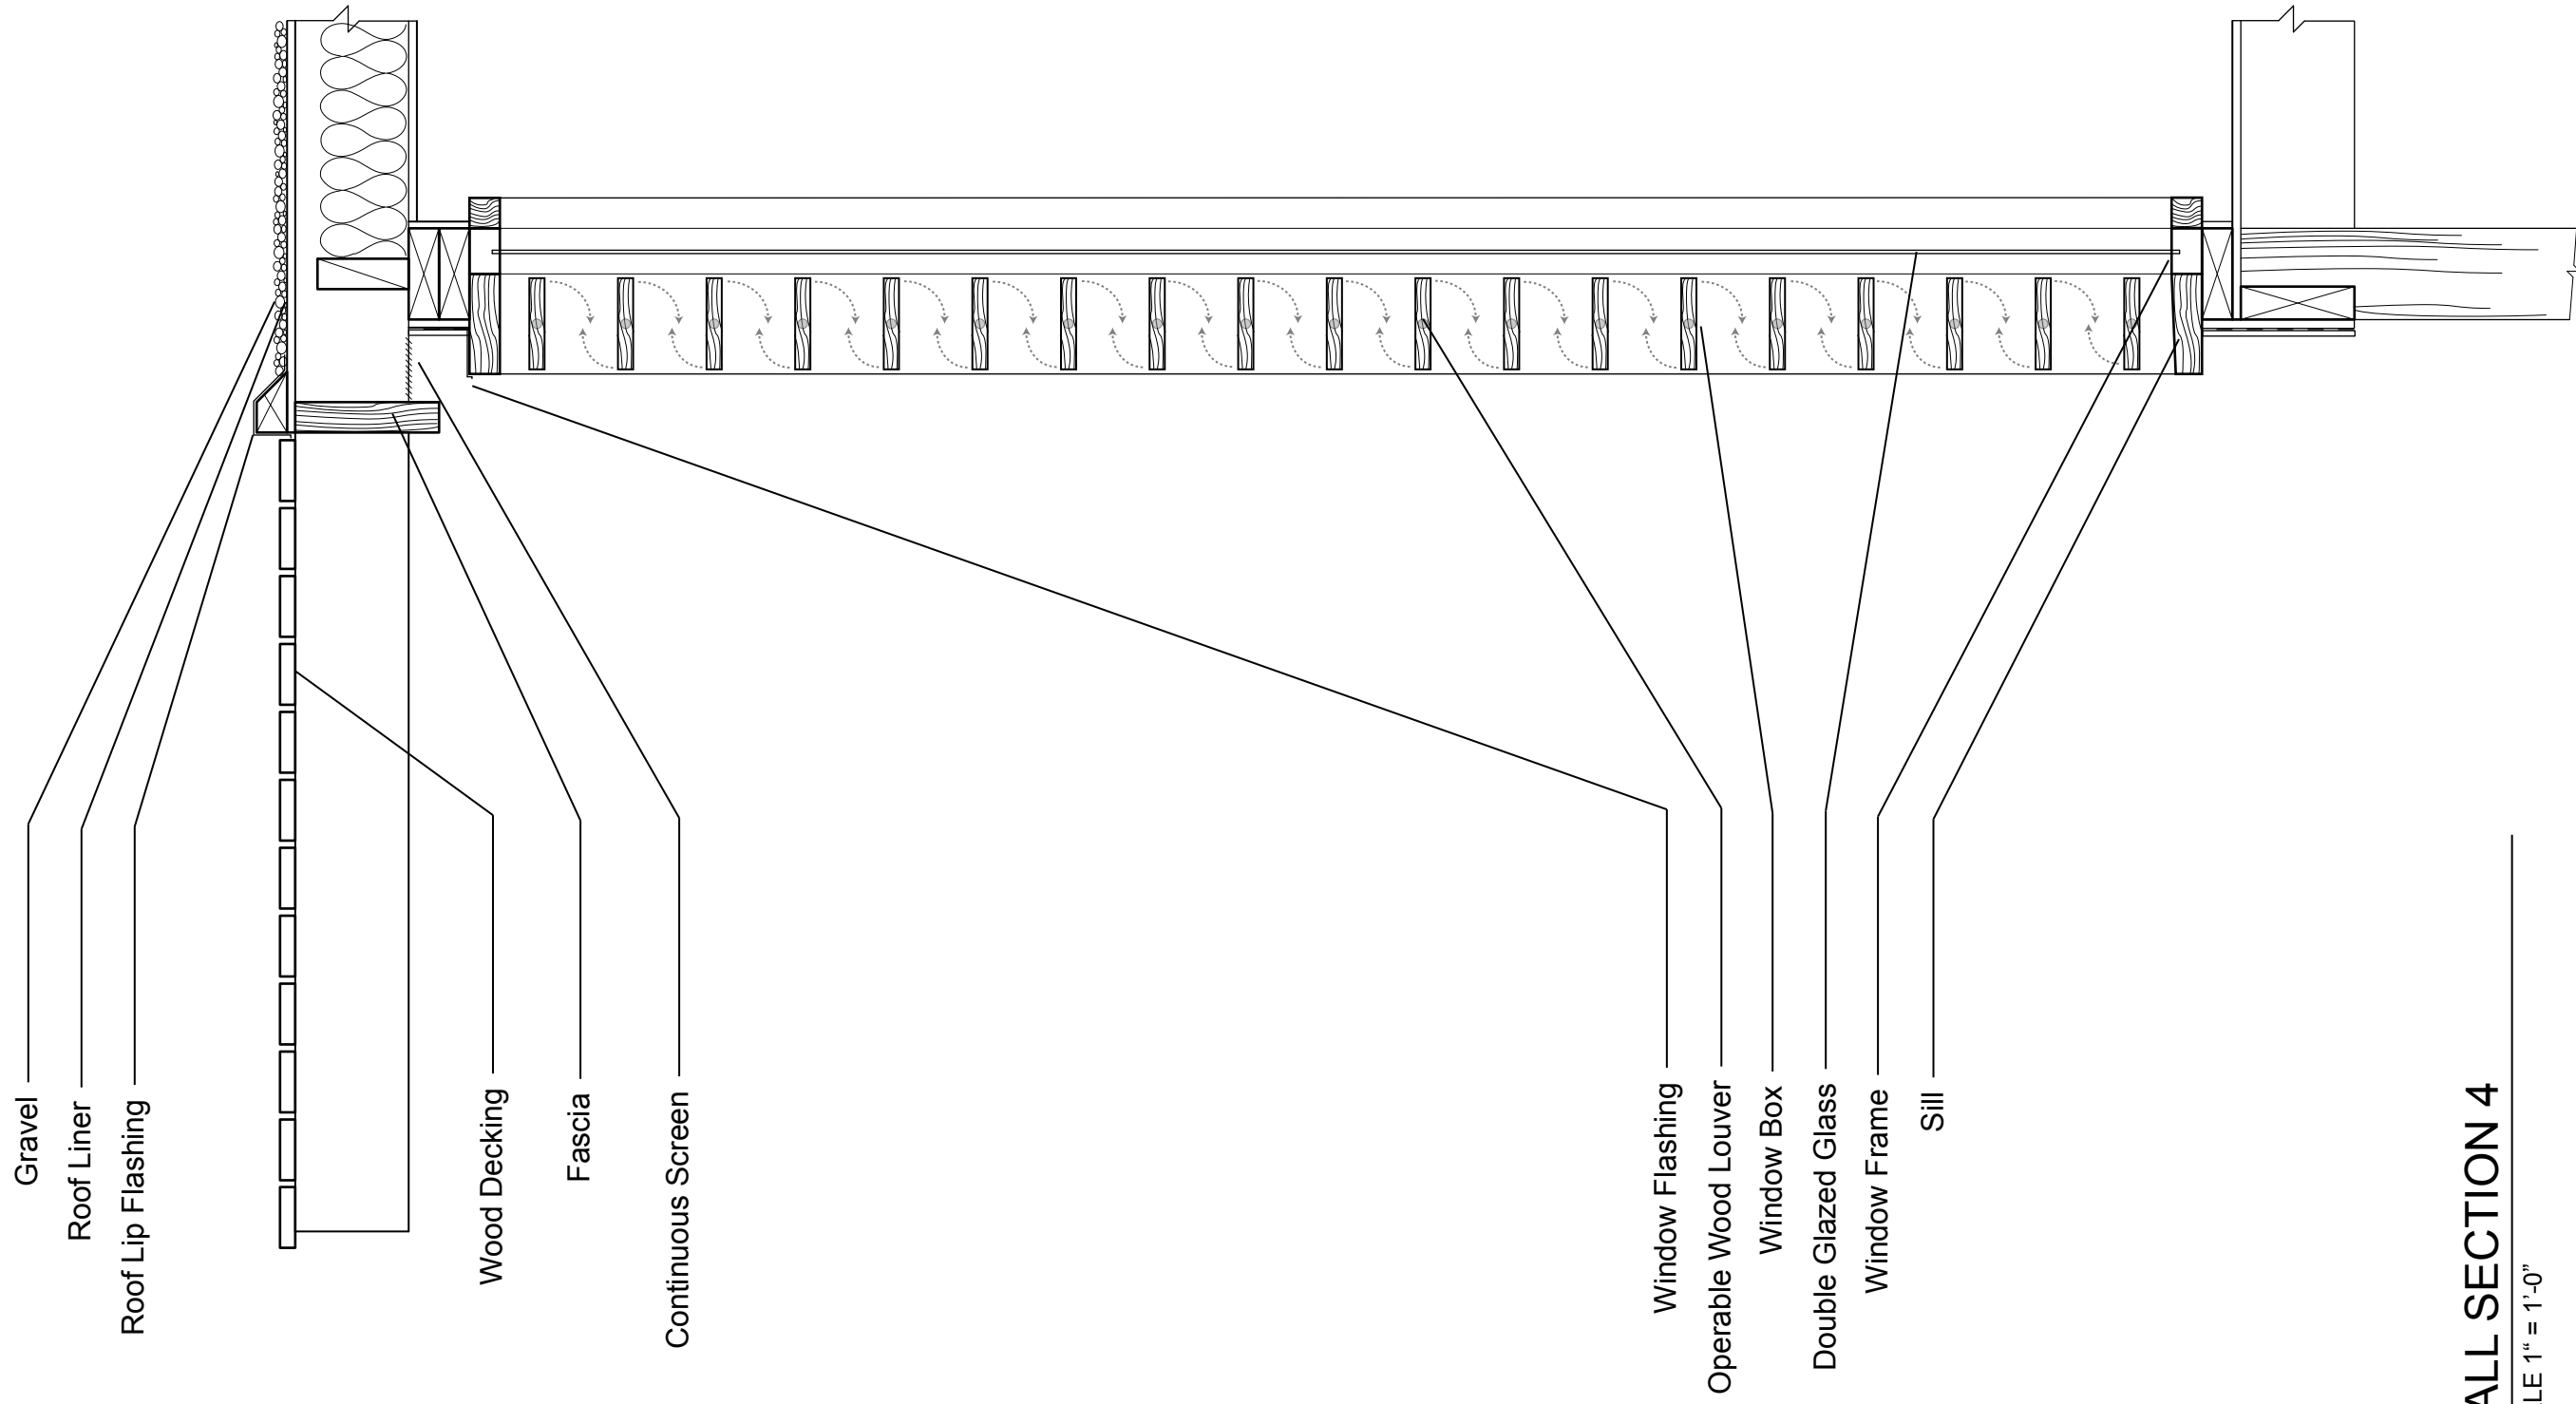

1 WALL SECTION 4

SCALE 1" = 1'-0"

MATERIALS AND ASSEMBLY  
HOT & HUMID  
BRASILIA, BRAZIL

A4.04  
Wall Section


FINAL SUBMISSION  
APRIL 23,  
2009

Sara Gotschewski

Kevin Rodriguez

Ryan Ralston

SKR  
ARCHITECTS

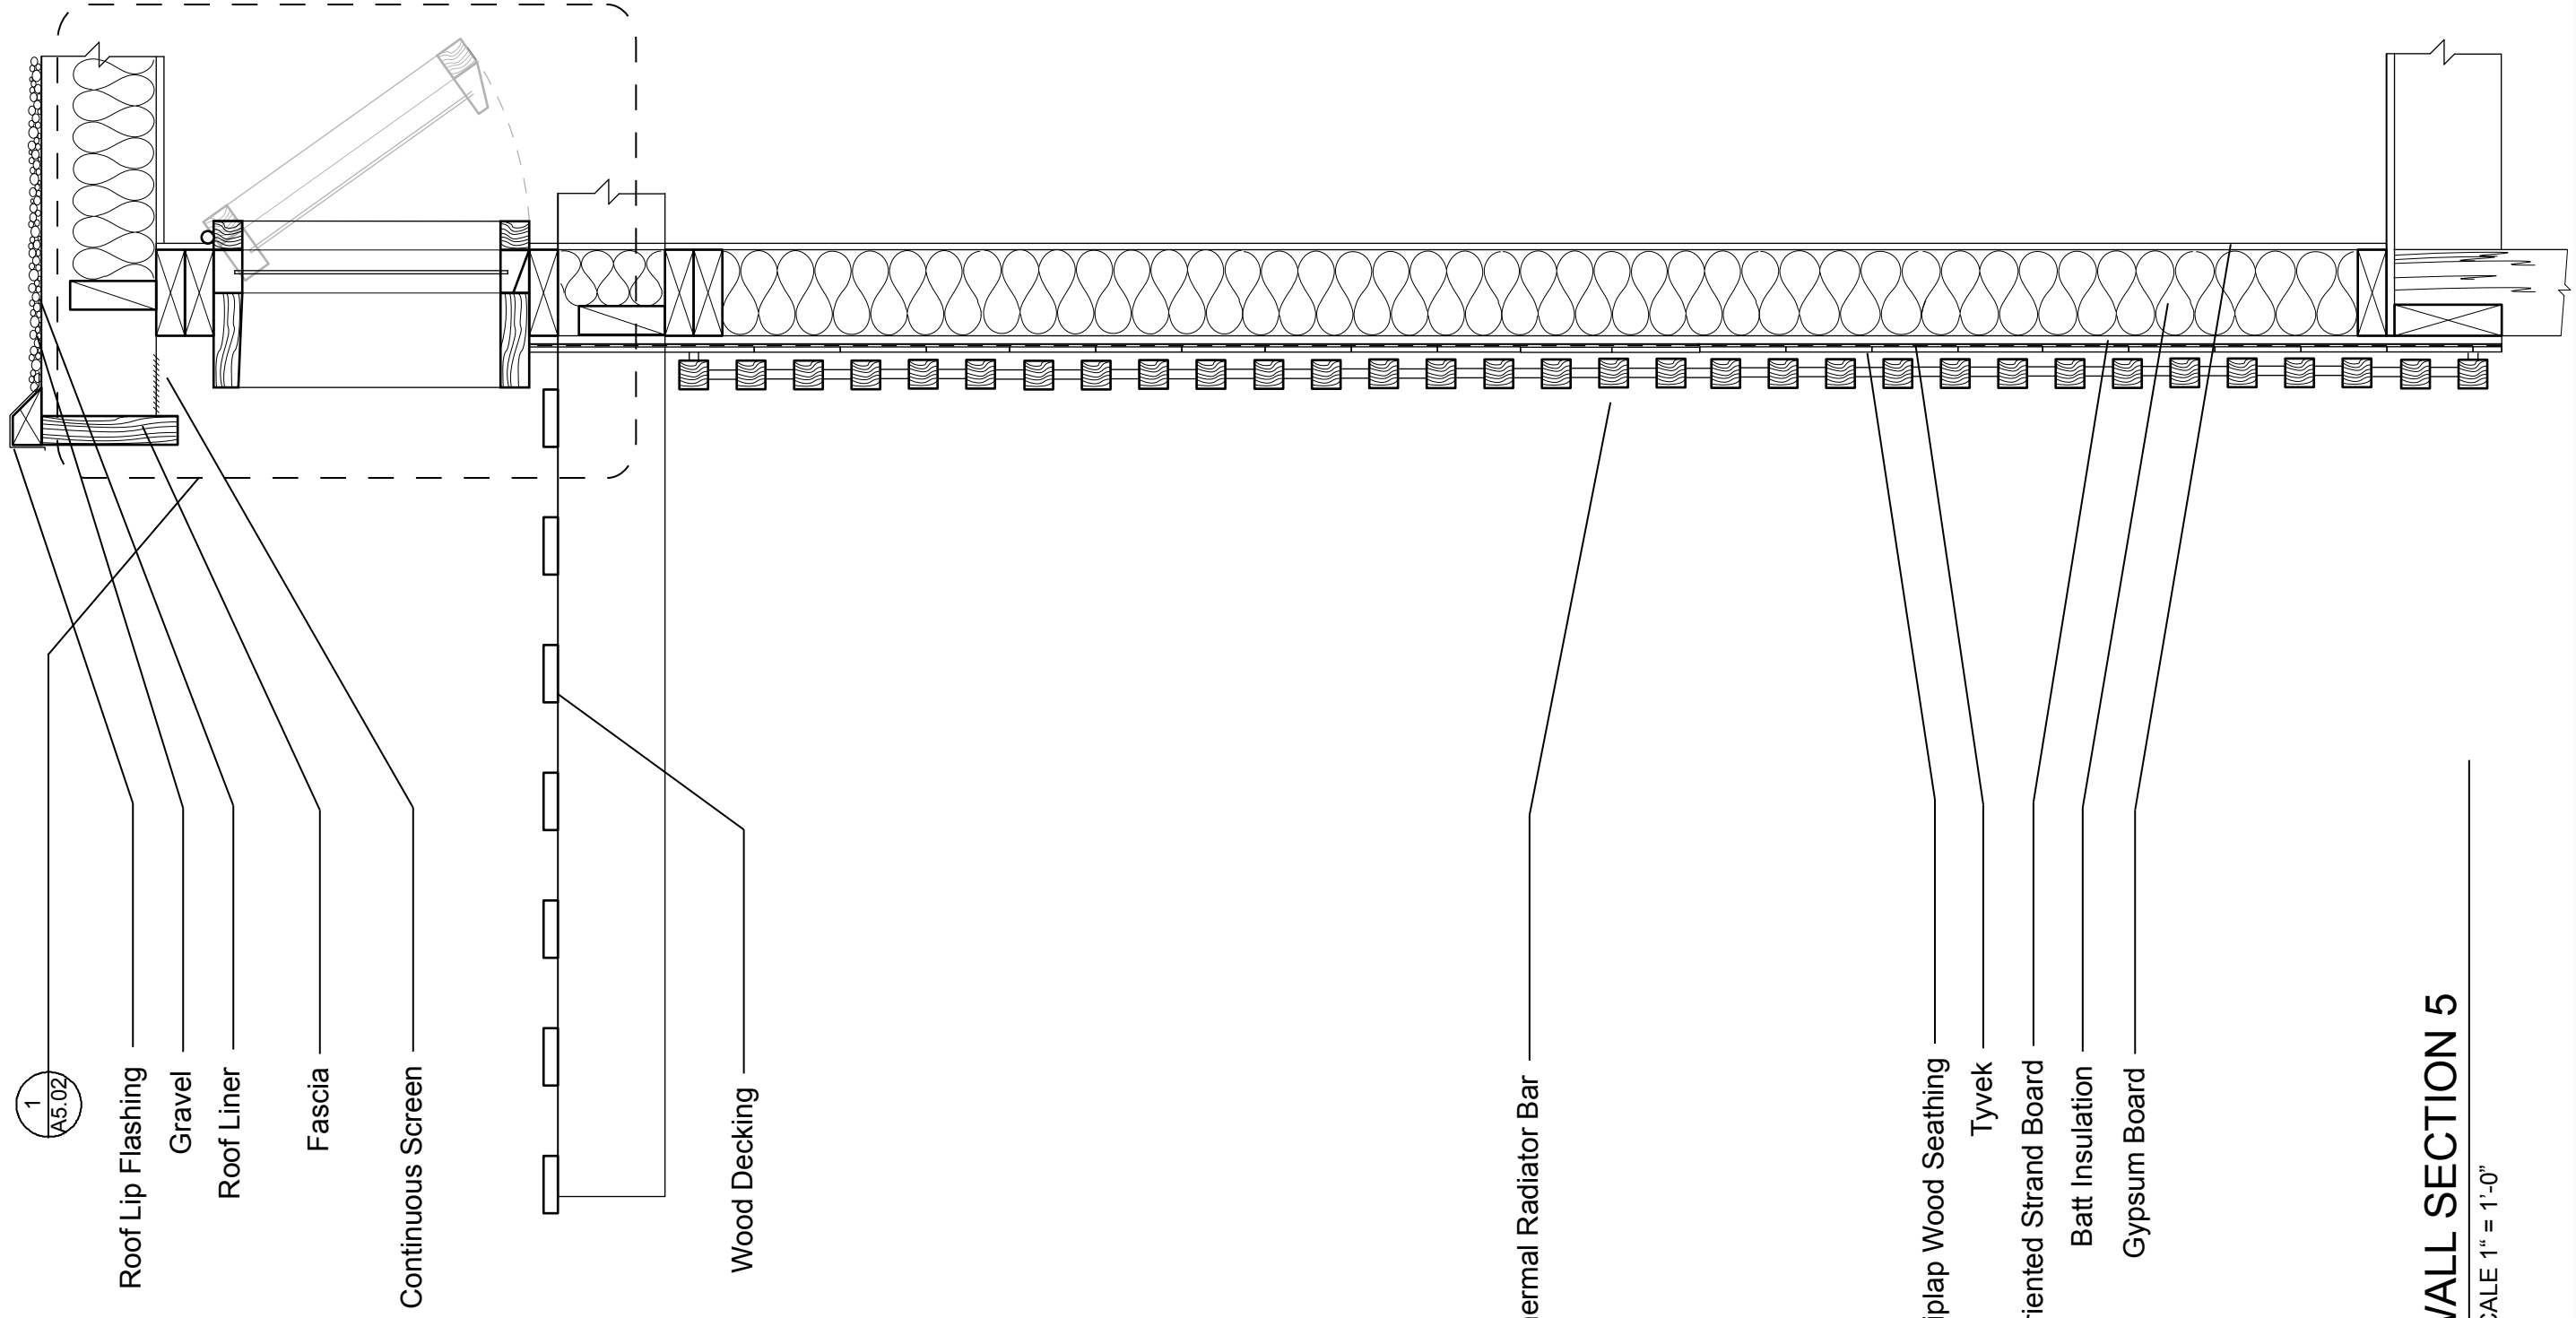

1  
A5.02

Roof Lip Flashing  
Gravel  
Roof Liner  
Fascia  
Continuous Screen

Wood Decking

Thermal Radiator Bar

Shiplap Wood Seathing  
Tyvek  
Oriented Strand Board  
Batt Insulation  
Gypsum Board

1  
WALL SECTION 5

SCALE 1" = 1'-0"

MATERIALS AND ASSEMBLY  
HOT & HUMID  
BRASILIA, BRAZIL


A4.05  
Wall Section

FINAL SUBMISSION  
APRIL 23,  
2009


Sara Gotschewski  
Kevin Rodriguez  
Ryan Ralston





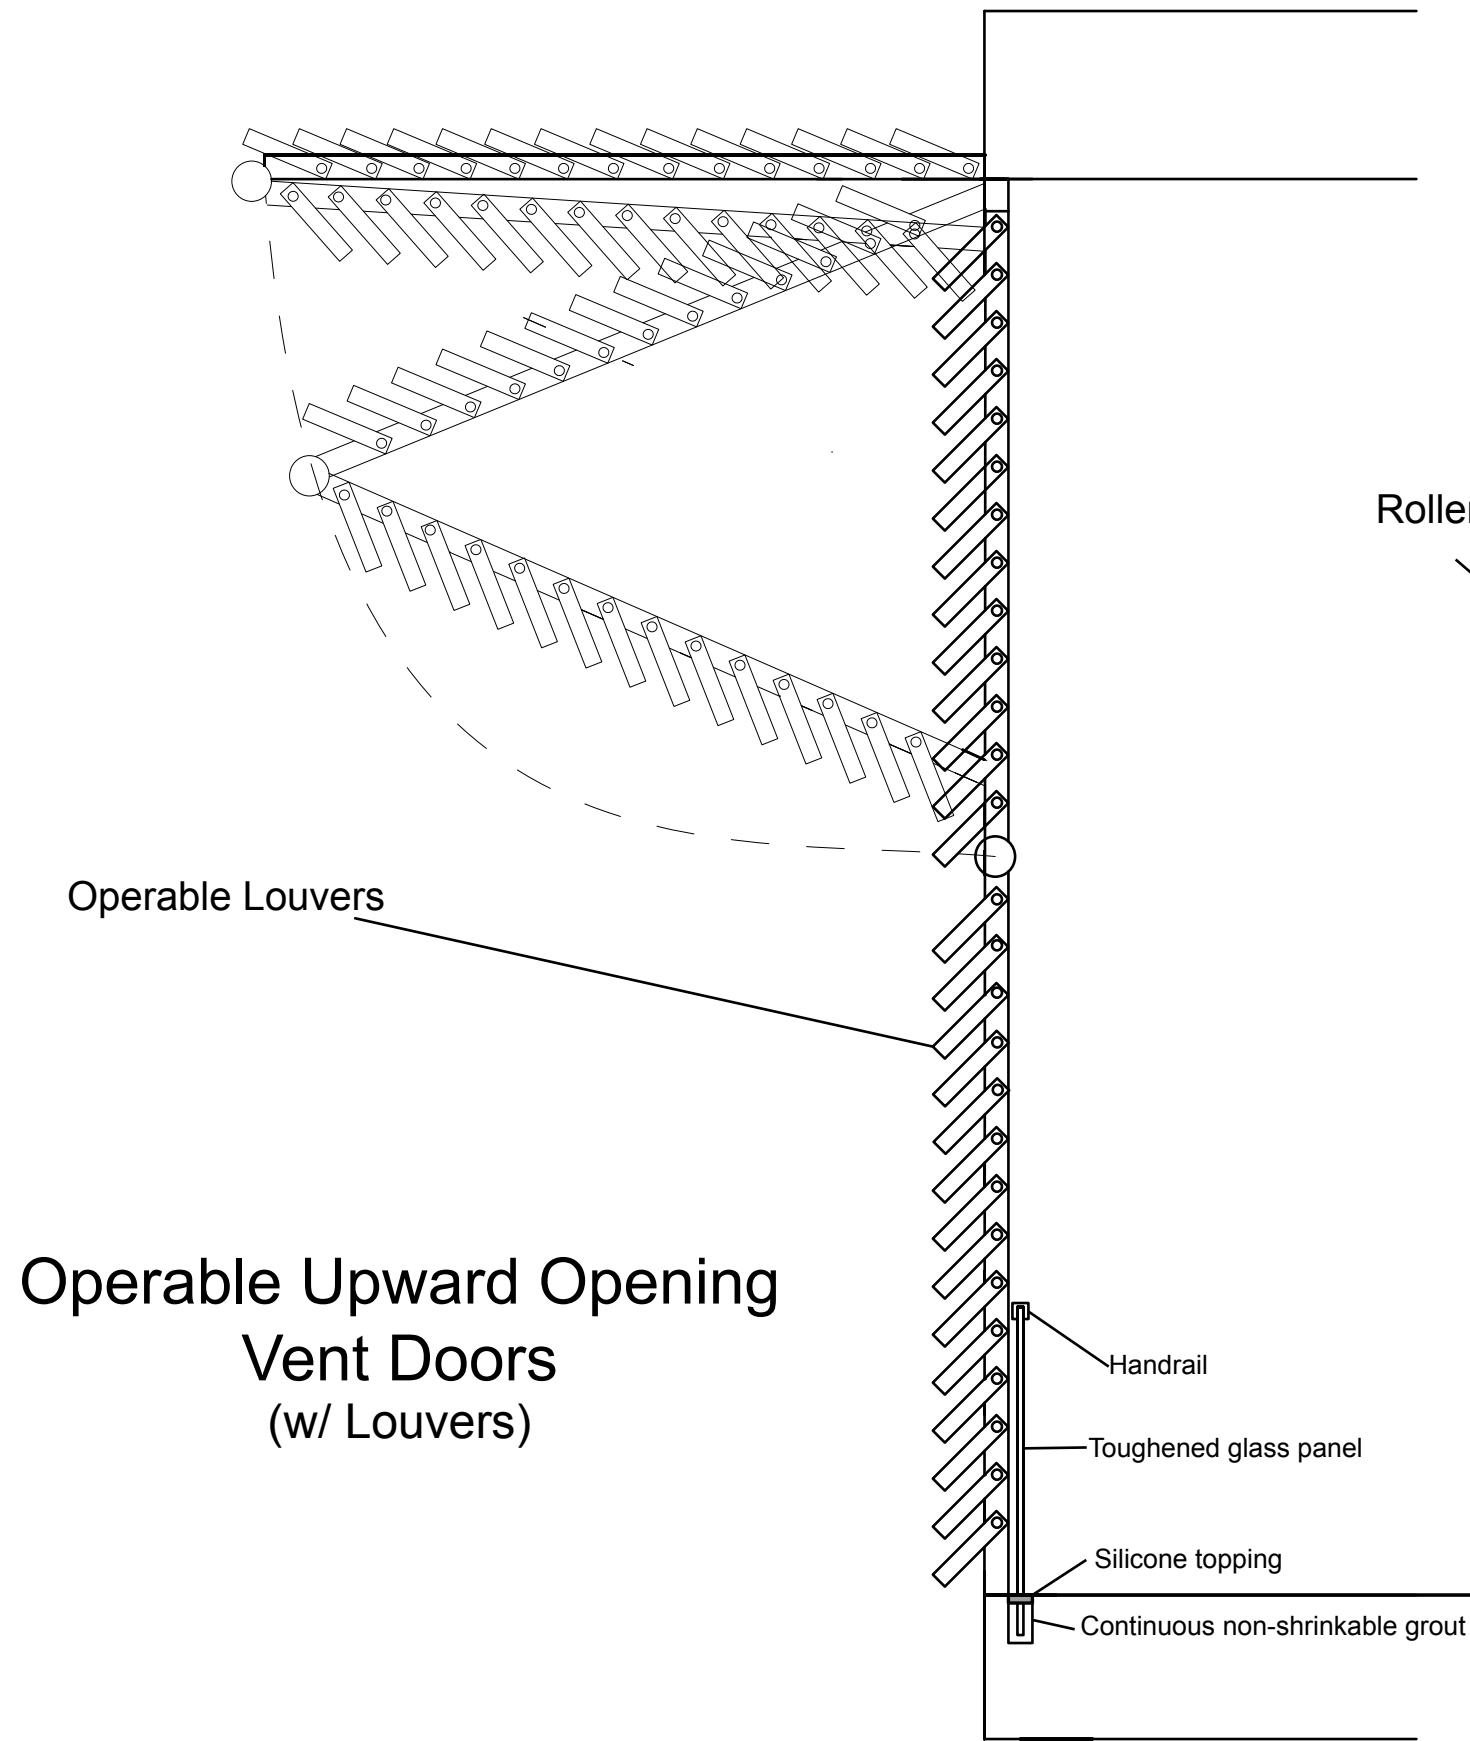

1 SECTION DETAIL  
SCALE 1/4" = 1'

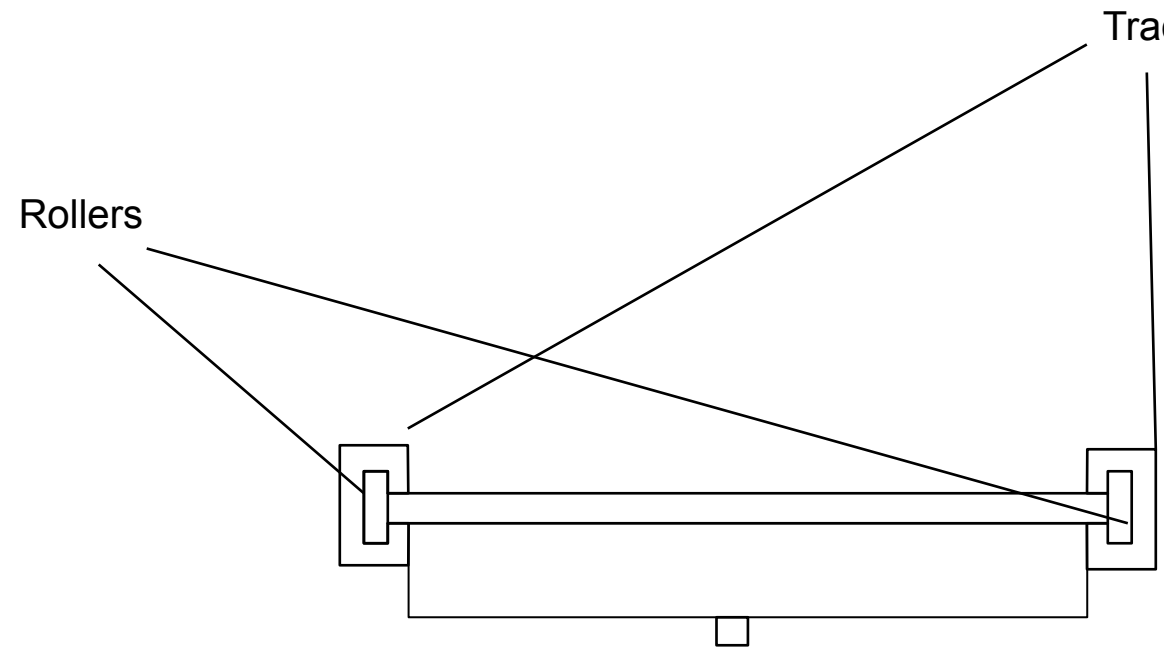

2 PLAN DETAIL  
SCALE 1/4" = 1'

Operable Upward Opening  
Vent Doors  
(w/ Louvers)

MATERIALS AND ASSEMBLY  
HOT & HUMID  
BRASILIA, BRAZIL


A5.01  
Critical Detail

FINAL SUBMISSION  
APRIL 23,  
2009

Sara Gotschewski  
Kevin Rodriguez  
Ryan Ralston

SKR  
ARCHITECTS

# Operable Vent Window (w/ Swinging Hinge)

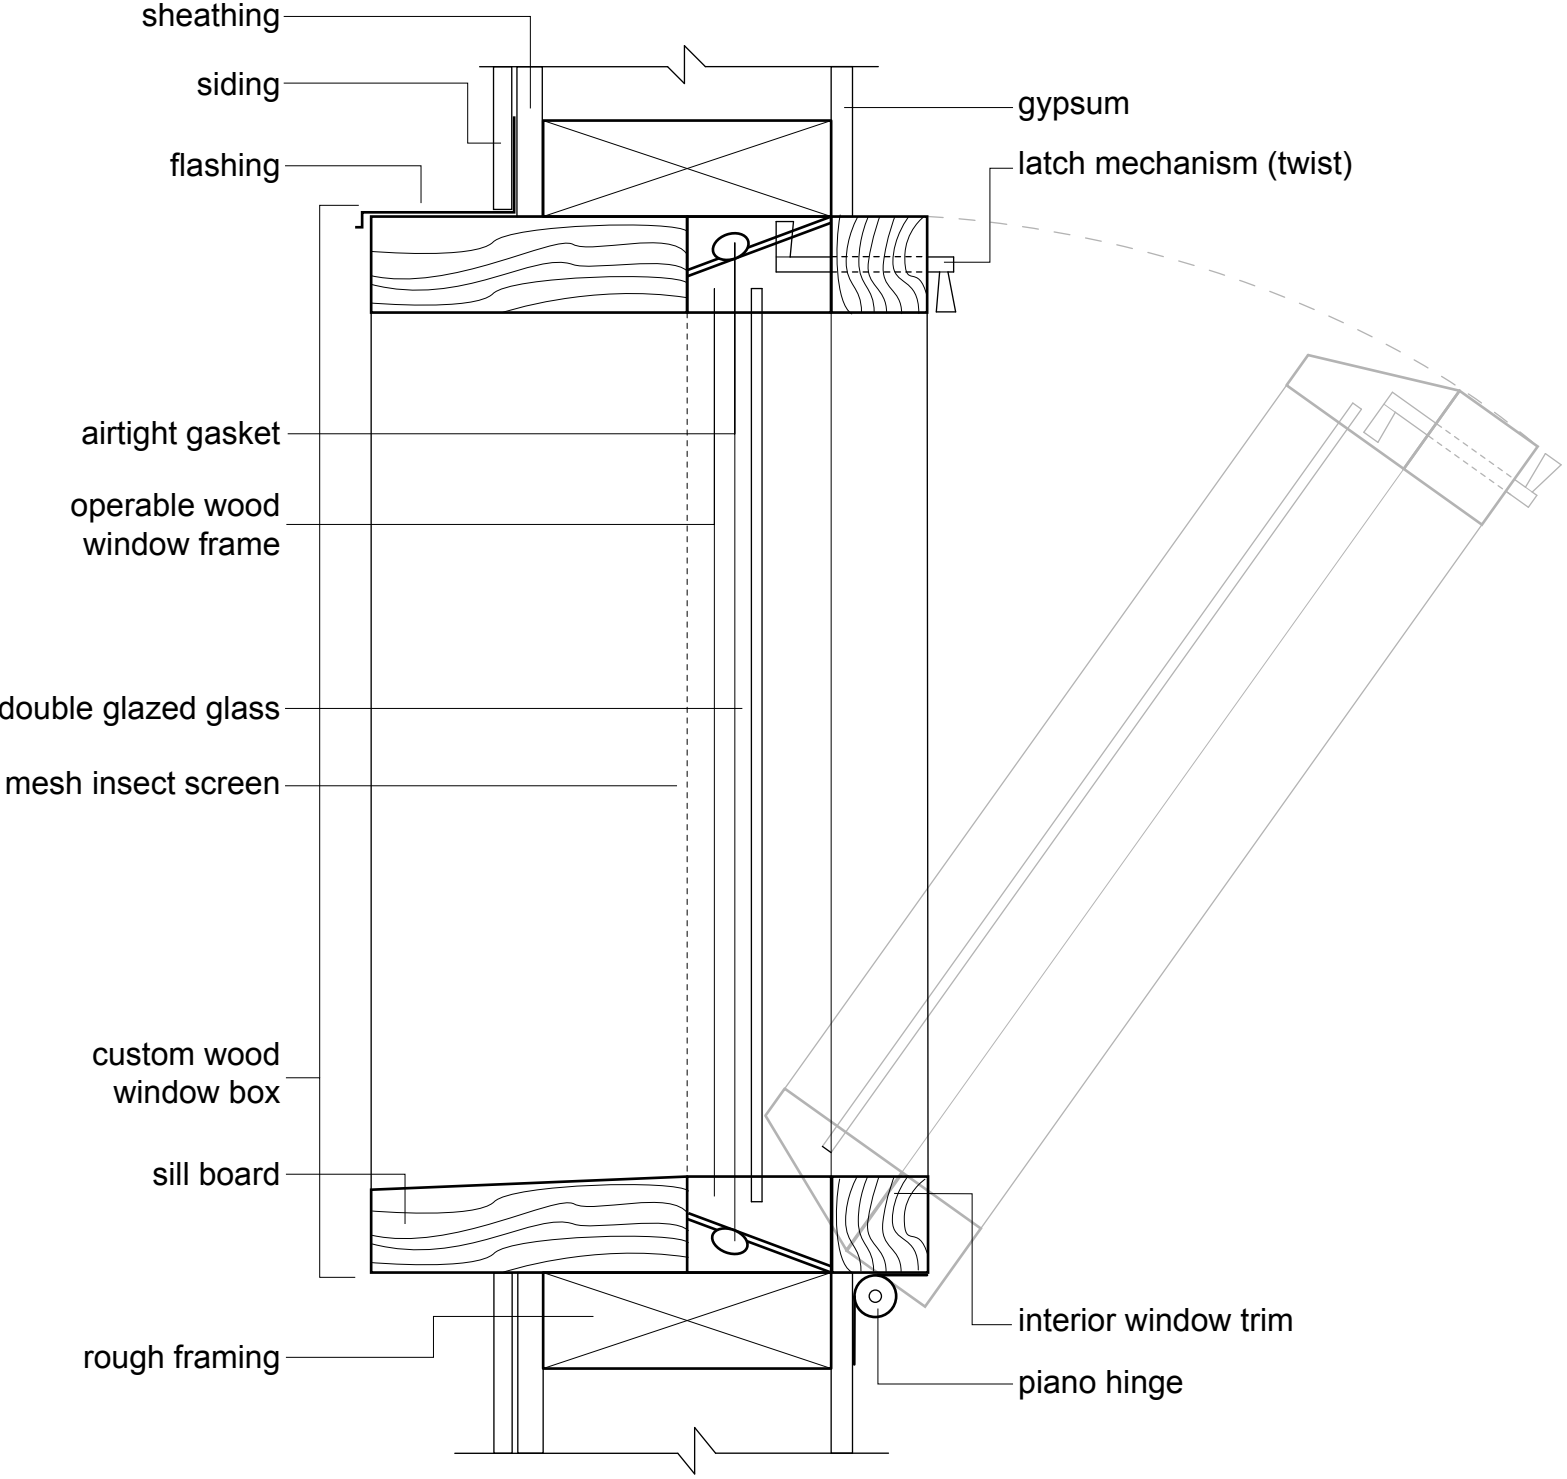

1 SECTION DETAIL  
SCALE 3" = 1'


MATERIALS AND ASSEMBLY  
HOT & HUMID  
BRASILIA, BRAZIL

A 5.02  
Critical Detail

FINAL SUBMISSION  
APRIL 23,  
2009

Sara Gotschewski  
Kevin Rodriguez  
Ryan Ralston


SKR  
ARCHITECTS

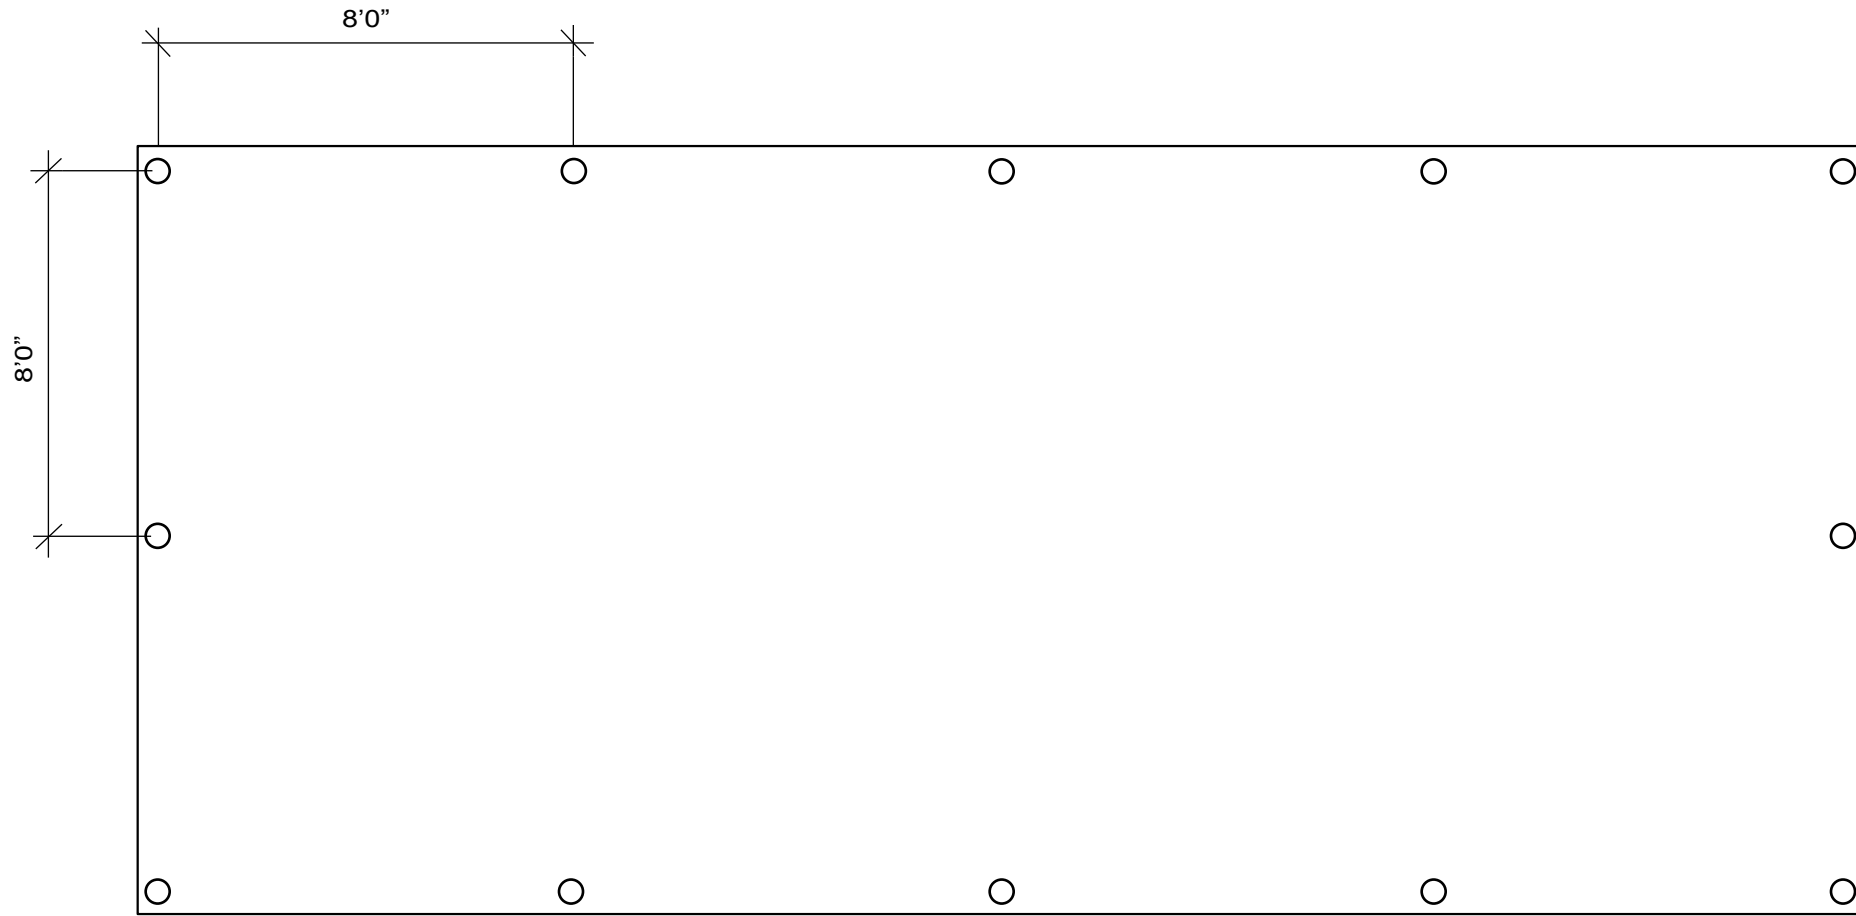

1

FOOTING PLAN

 SCALE 1/4" = 1'



MATERIALS AND ASSEMBLY  
HOT & HUMID  
BRASILIA, BRAZIL

S1.1  
Footing Plan


FINAL SUBMISSION  
APRIL 23,  
2009

Sara Gotschewski



Kevin Rodriguez

Ryan Ralston

SKR  
ARCHITECTS

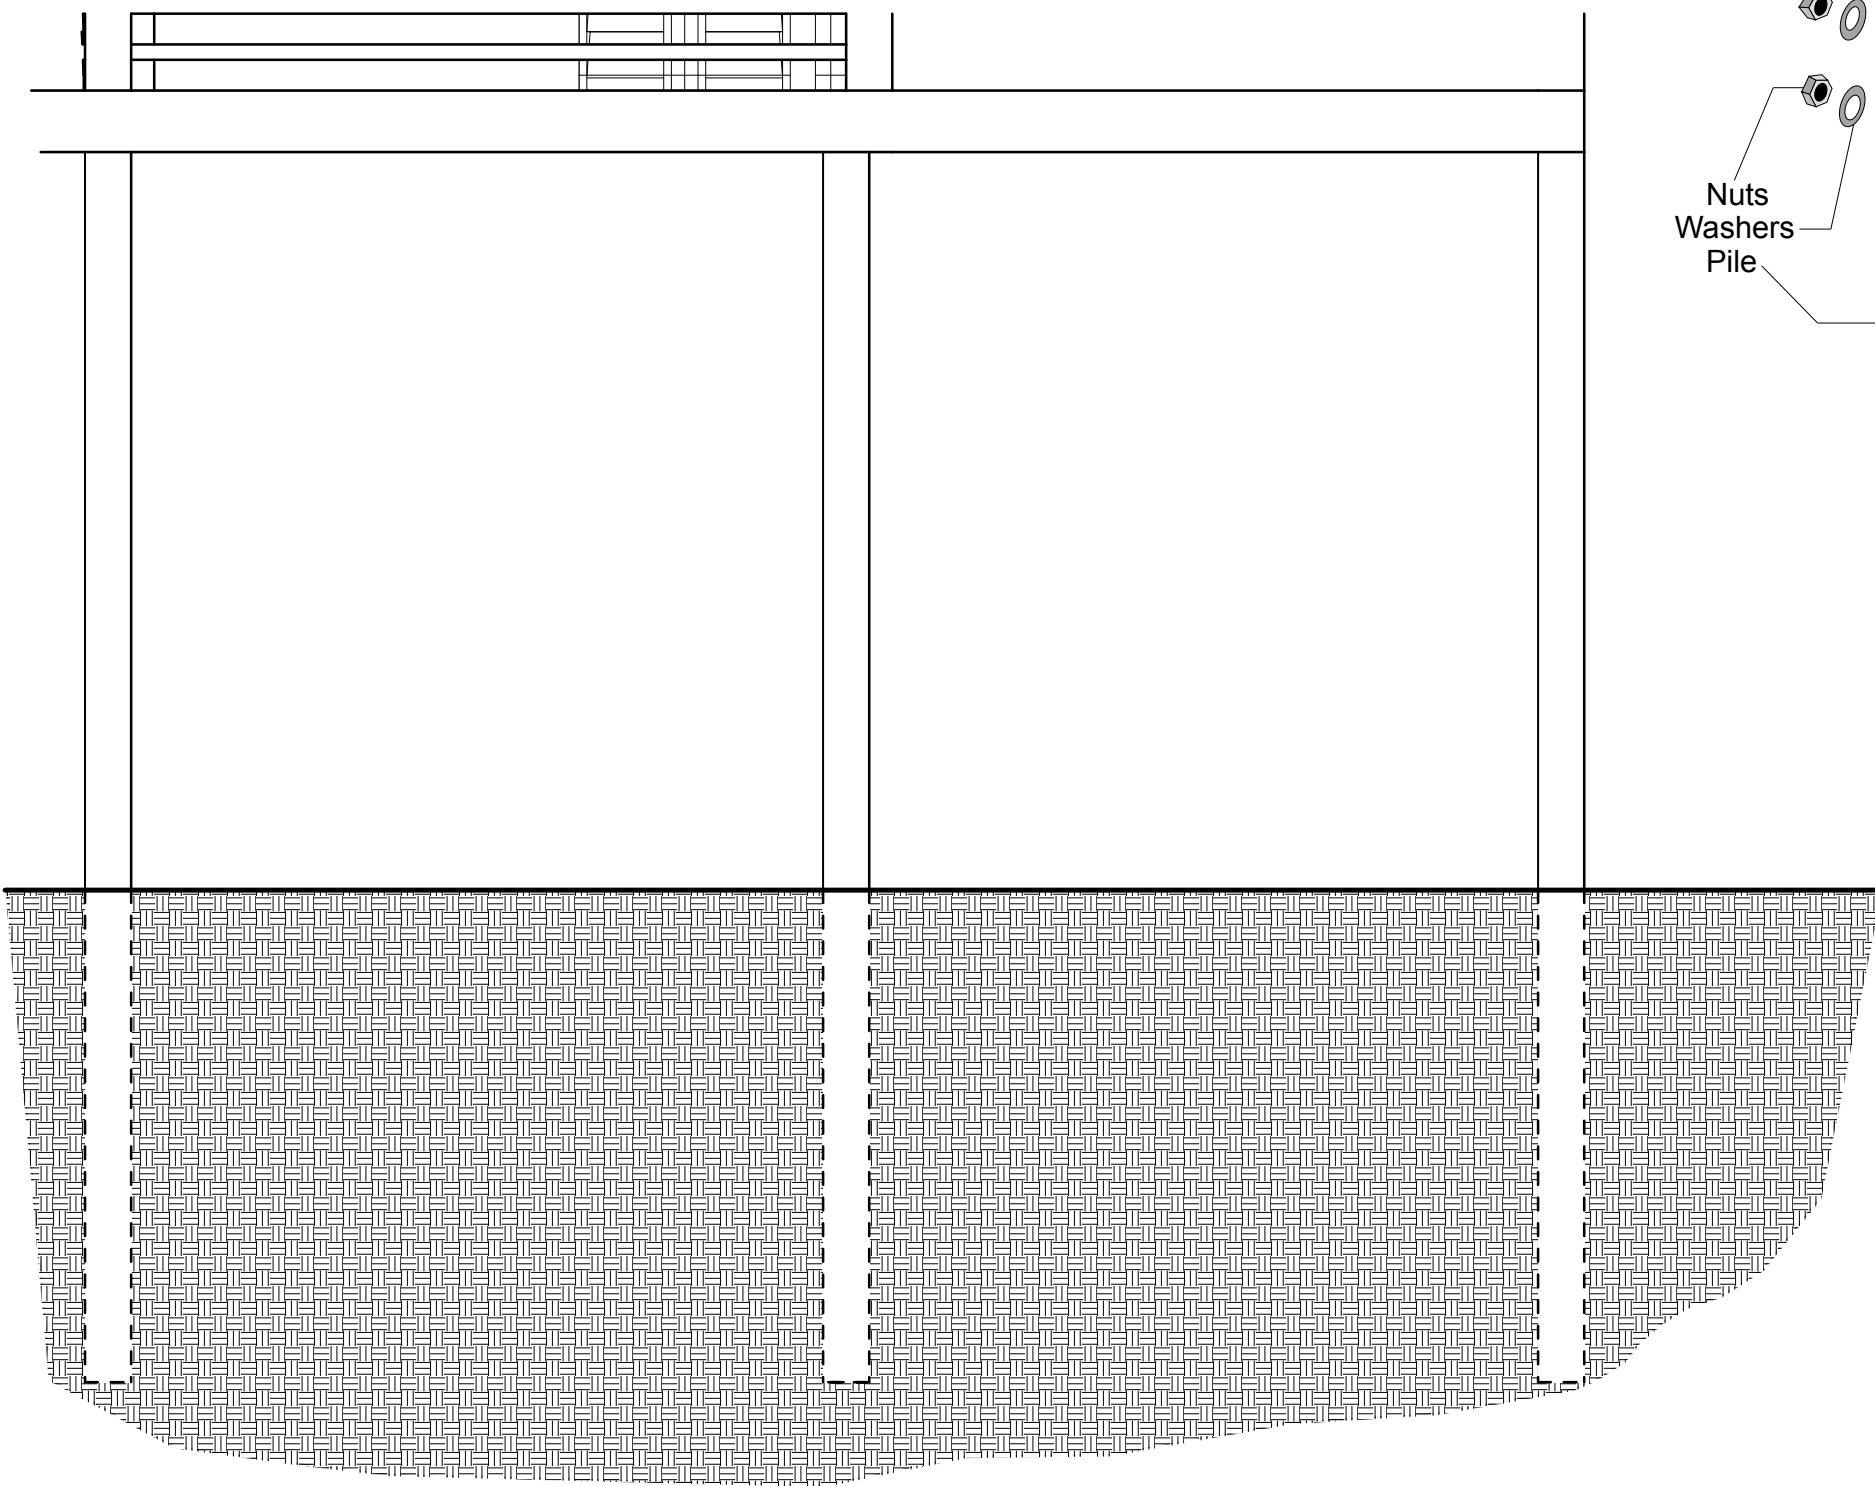

1 FOOTING SECTION  
SCALE 1/4" = 1'

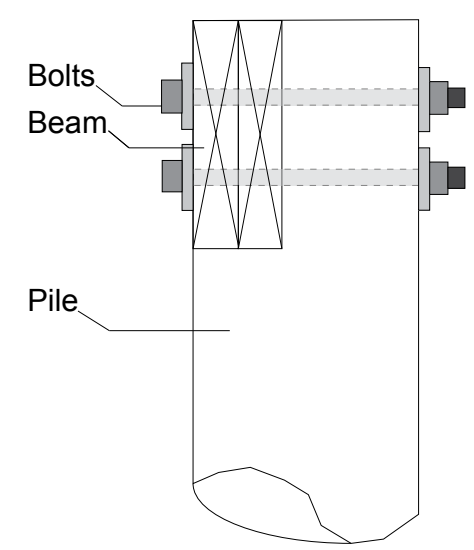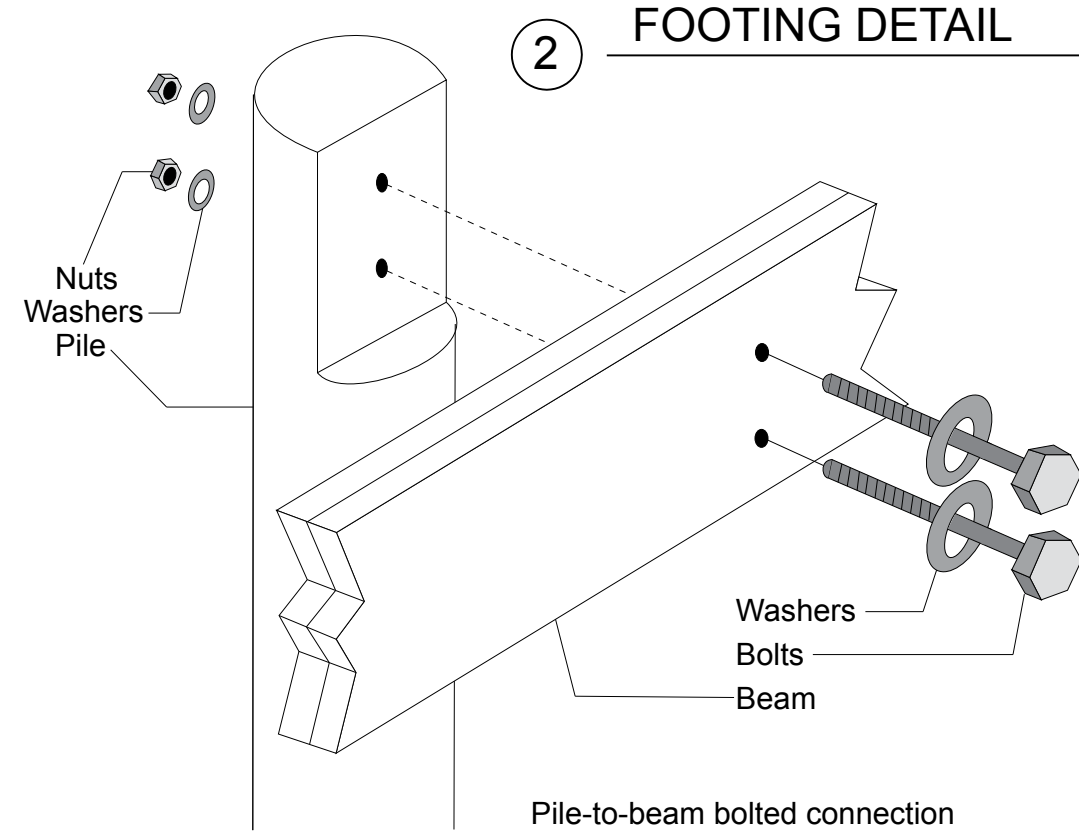


MATERIALS AND ASSEMBLY  
HOT & HUMID  
BRASILIA, BRAZIL

S1.2  
Footings Section  
& Detail


FINAL SUBMISSION  
APRIL 23,  
2009

Sara Gotschewski  
Kevin Rodriguez  
Ryan Ralston



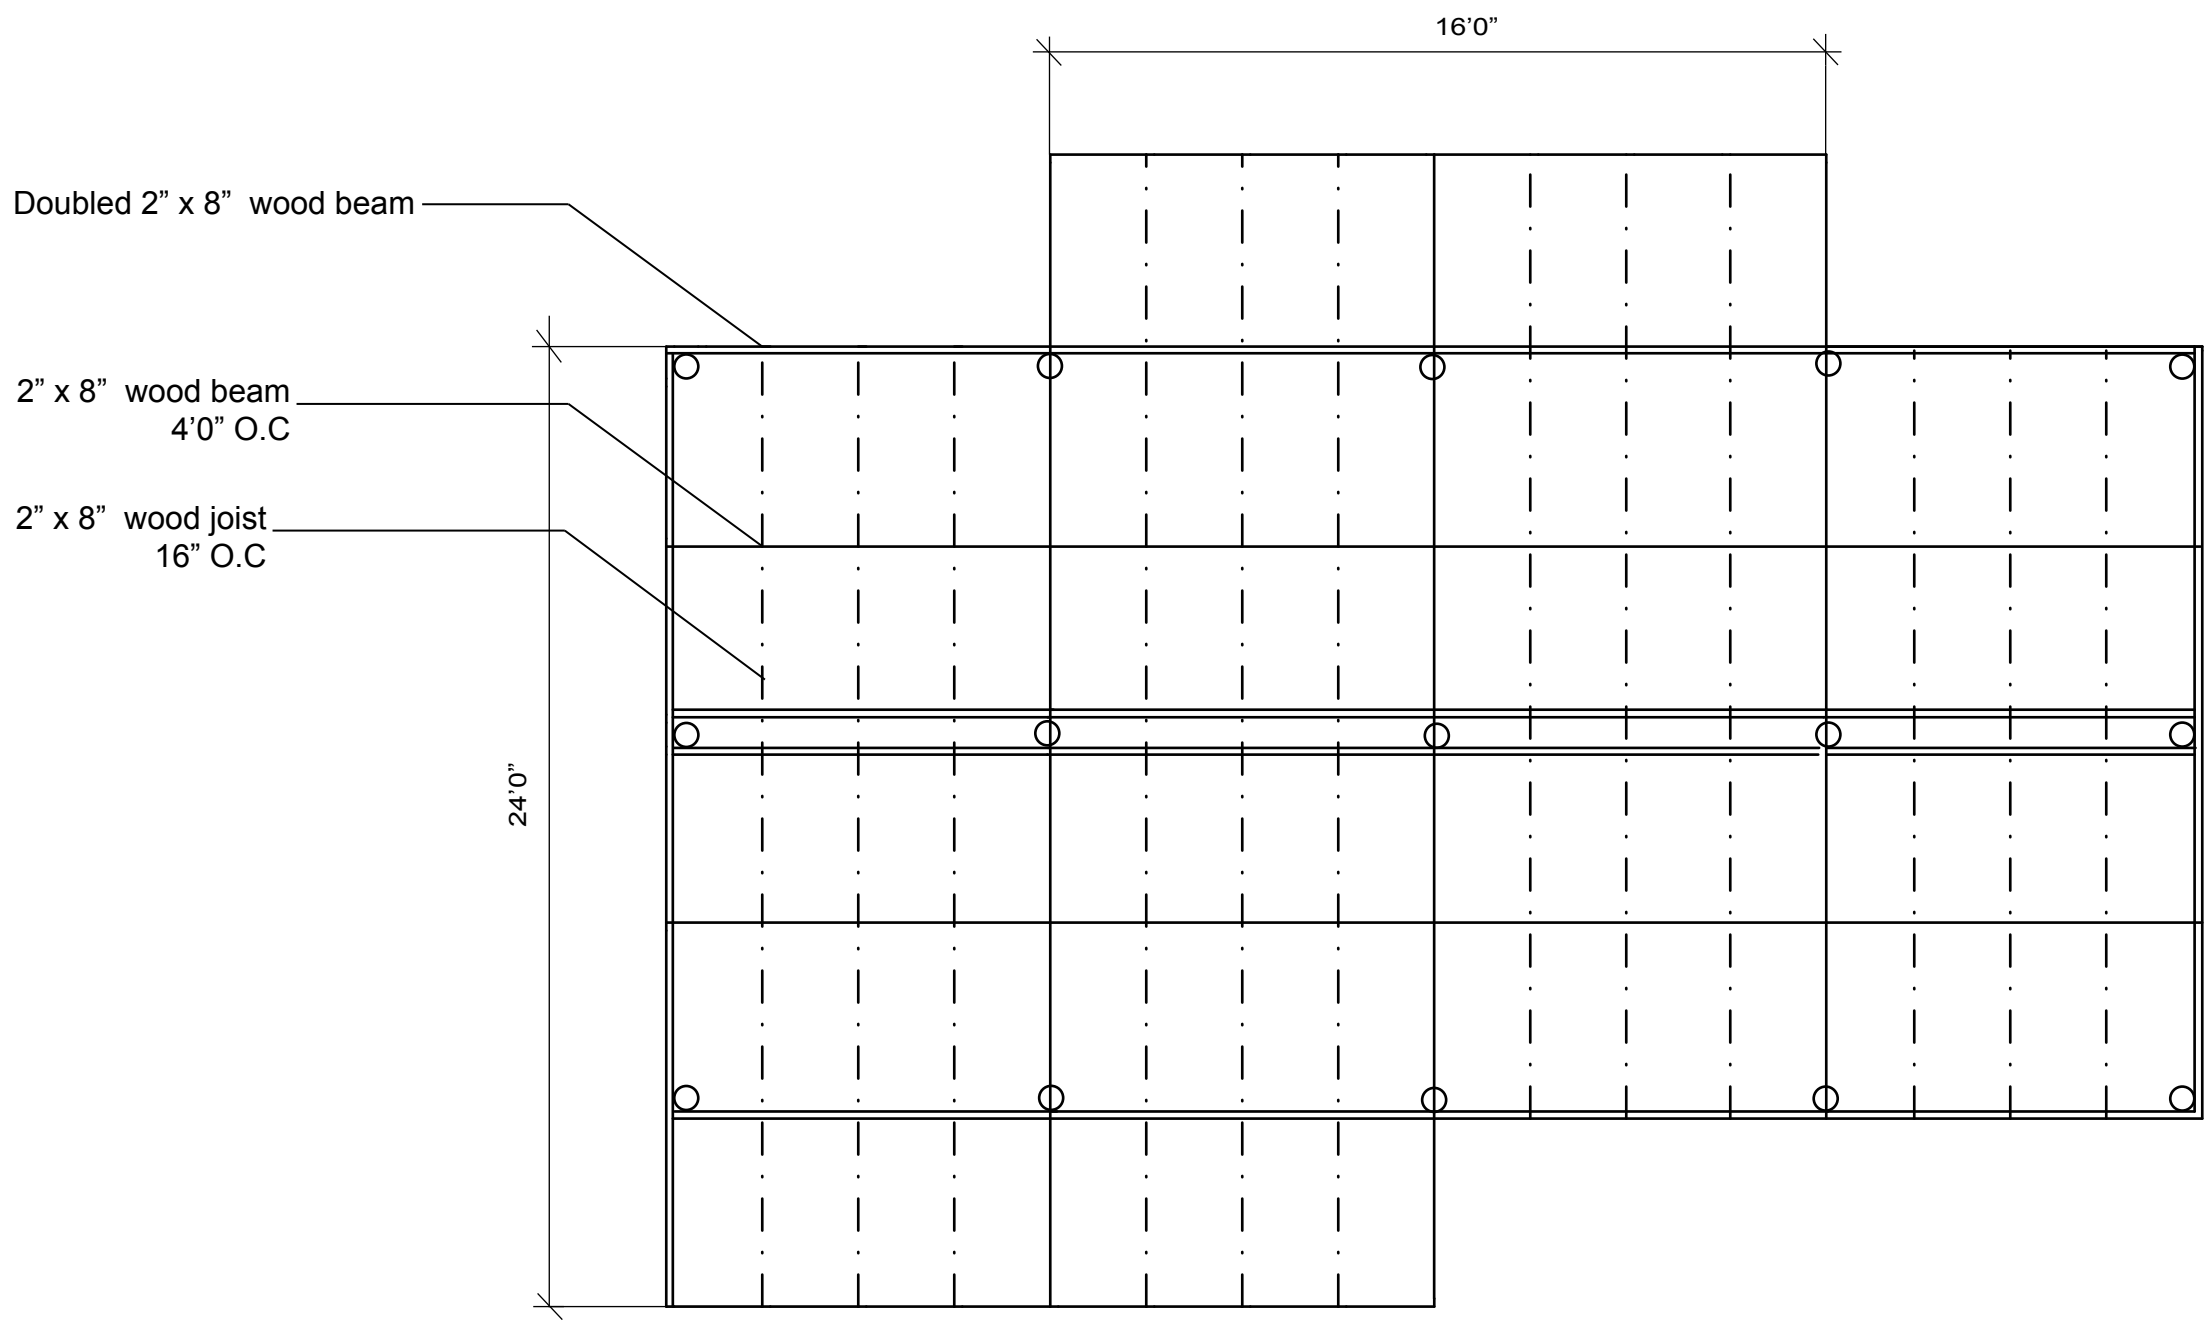

1 FLOOR STRUCTURE  
SCALE 1/4" = 1'

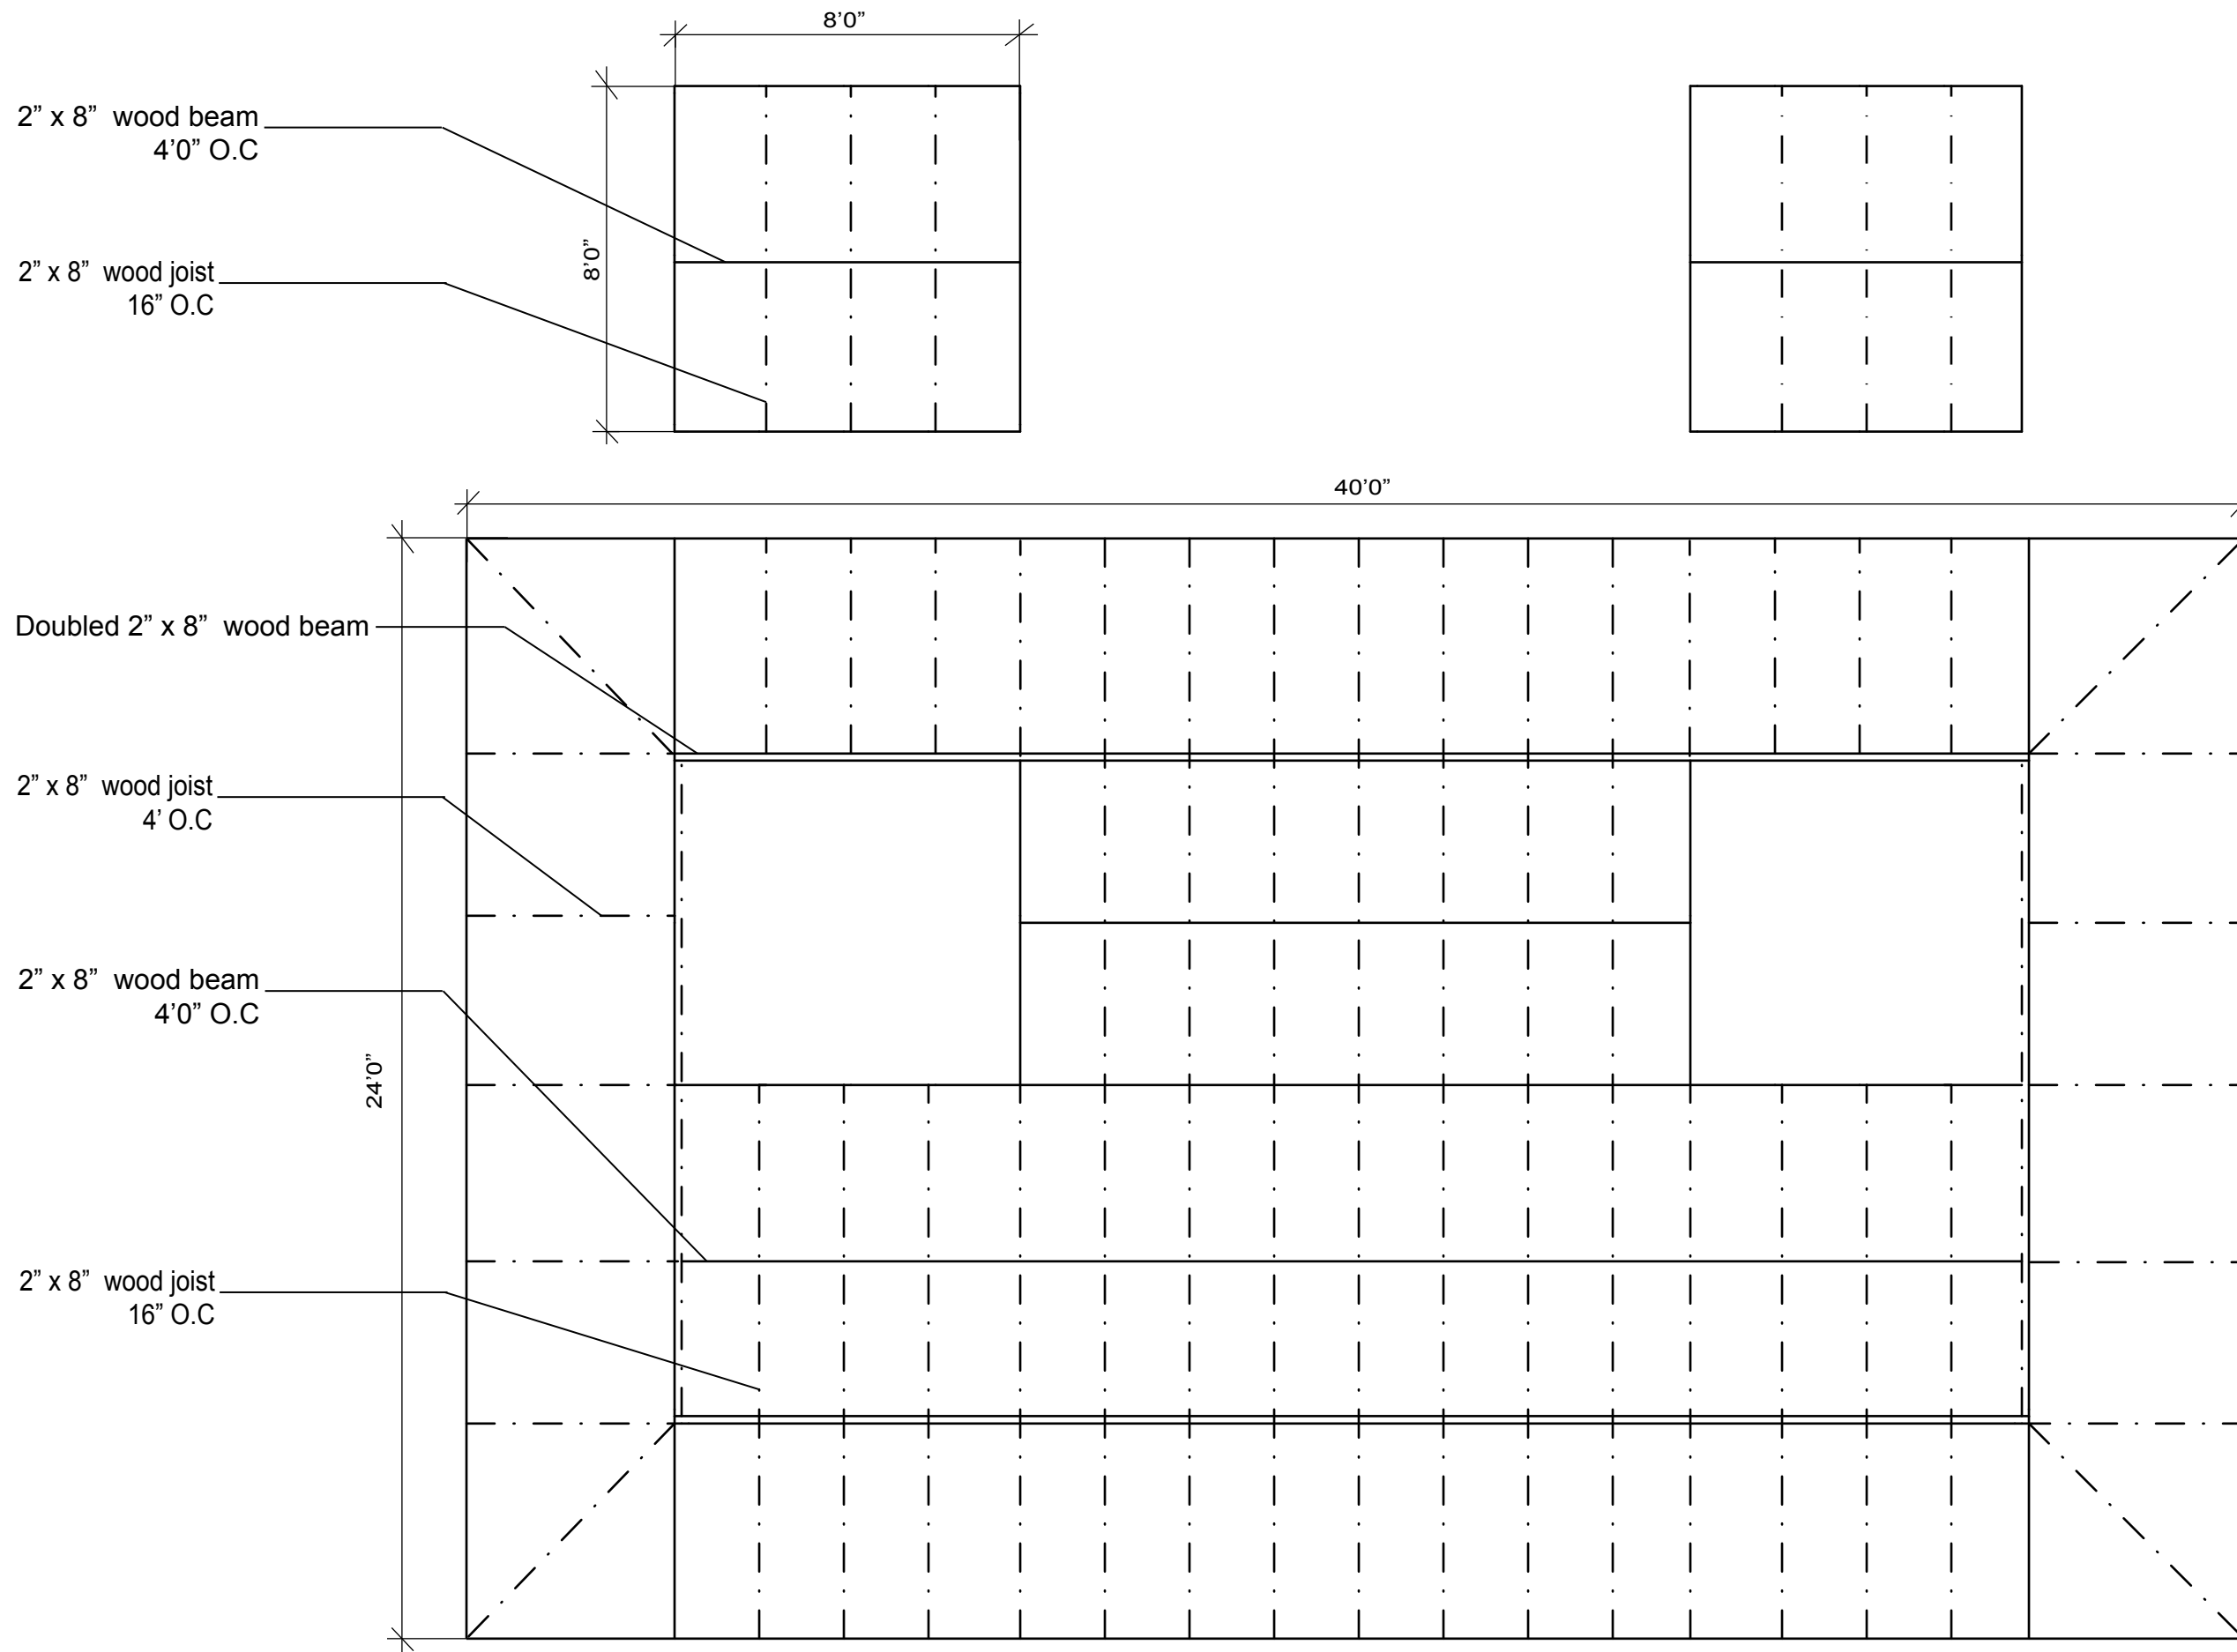

MATERIALS AND ASSEMBLY  
HOT & HUMID  
BRASILIA, BRAZIL

S 1.4  
Roof Structure

FINAL SUBMISSION  
APRIL 23,  
2009


Sara Gotschewski  
Kevin Rodriguez  
Ryan Ralston



1

ROOF STRUCTURE

SCALE 1/4" = 1'

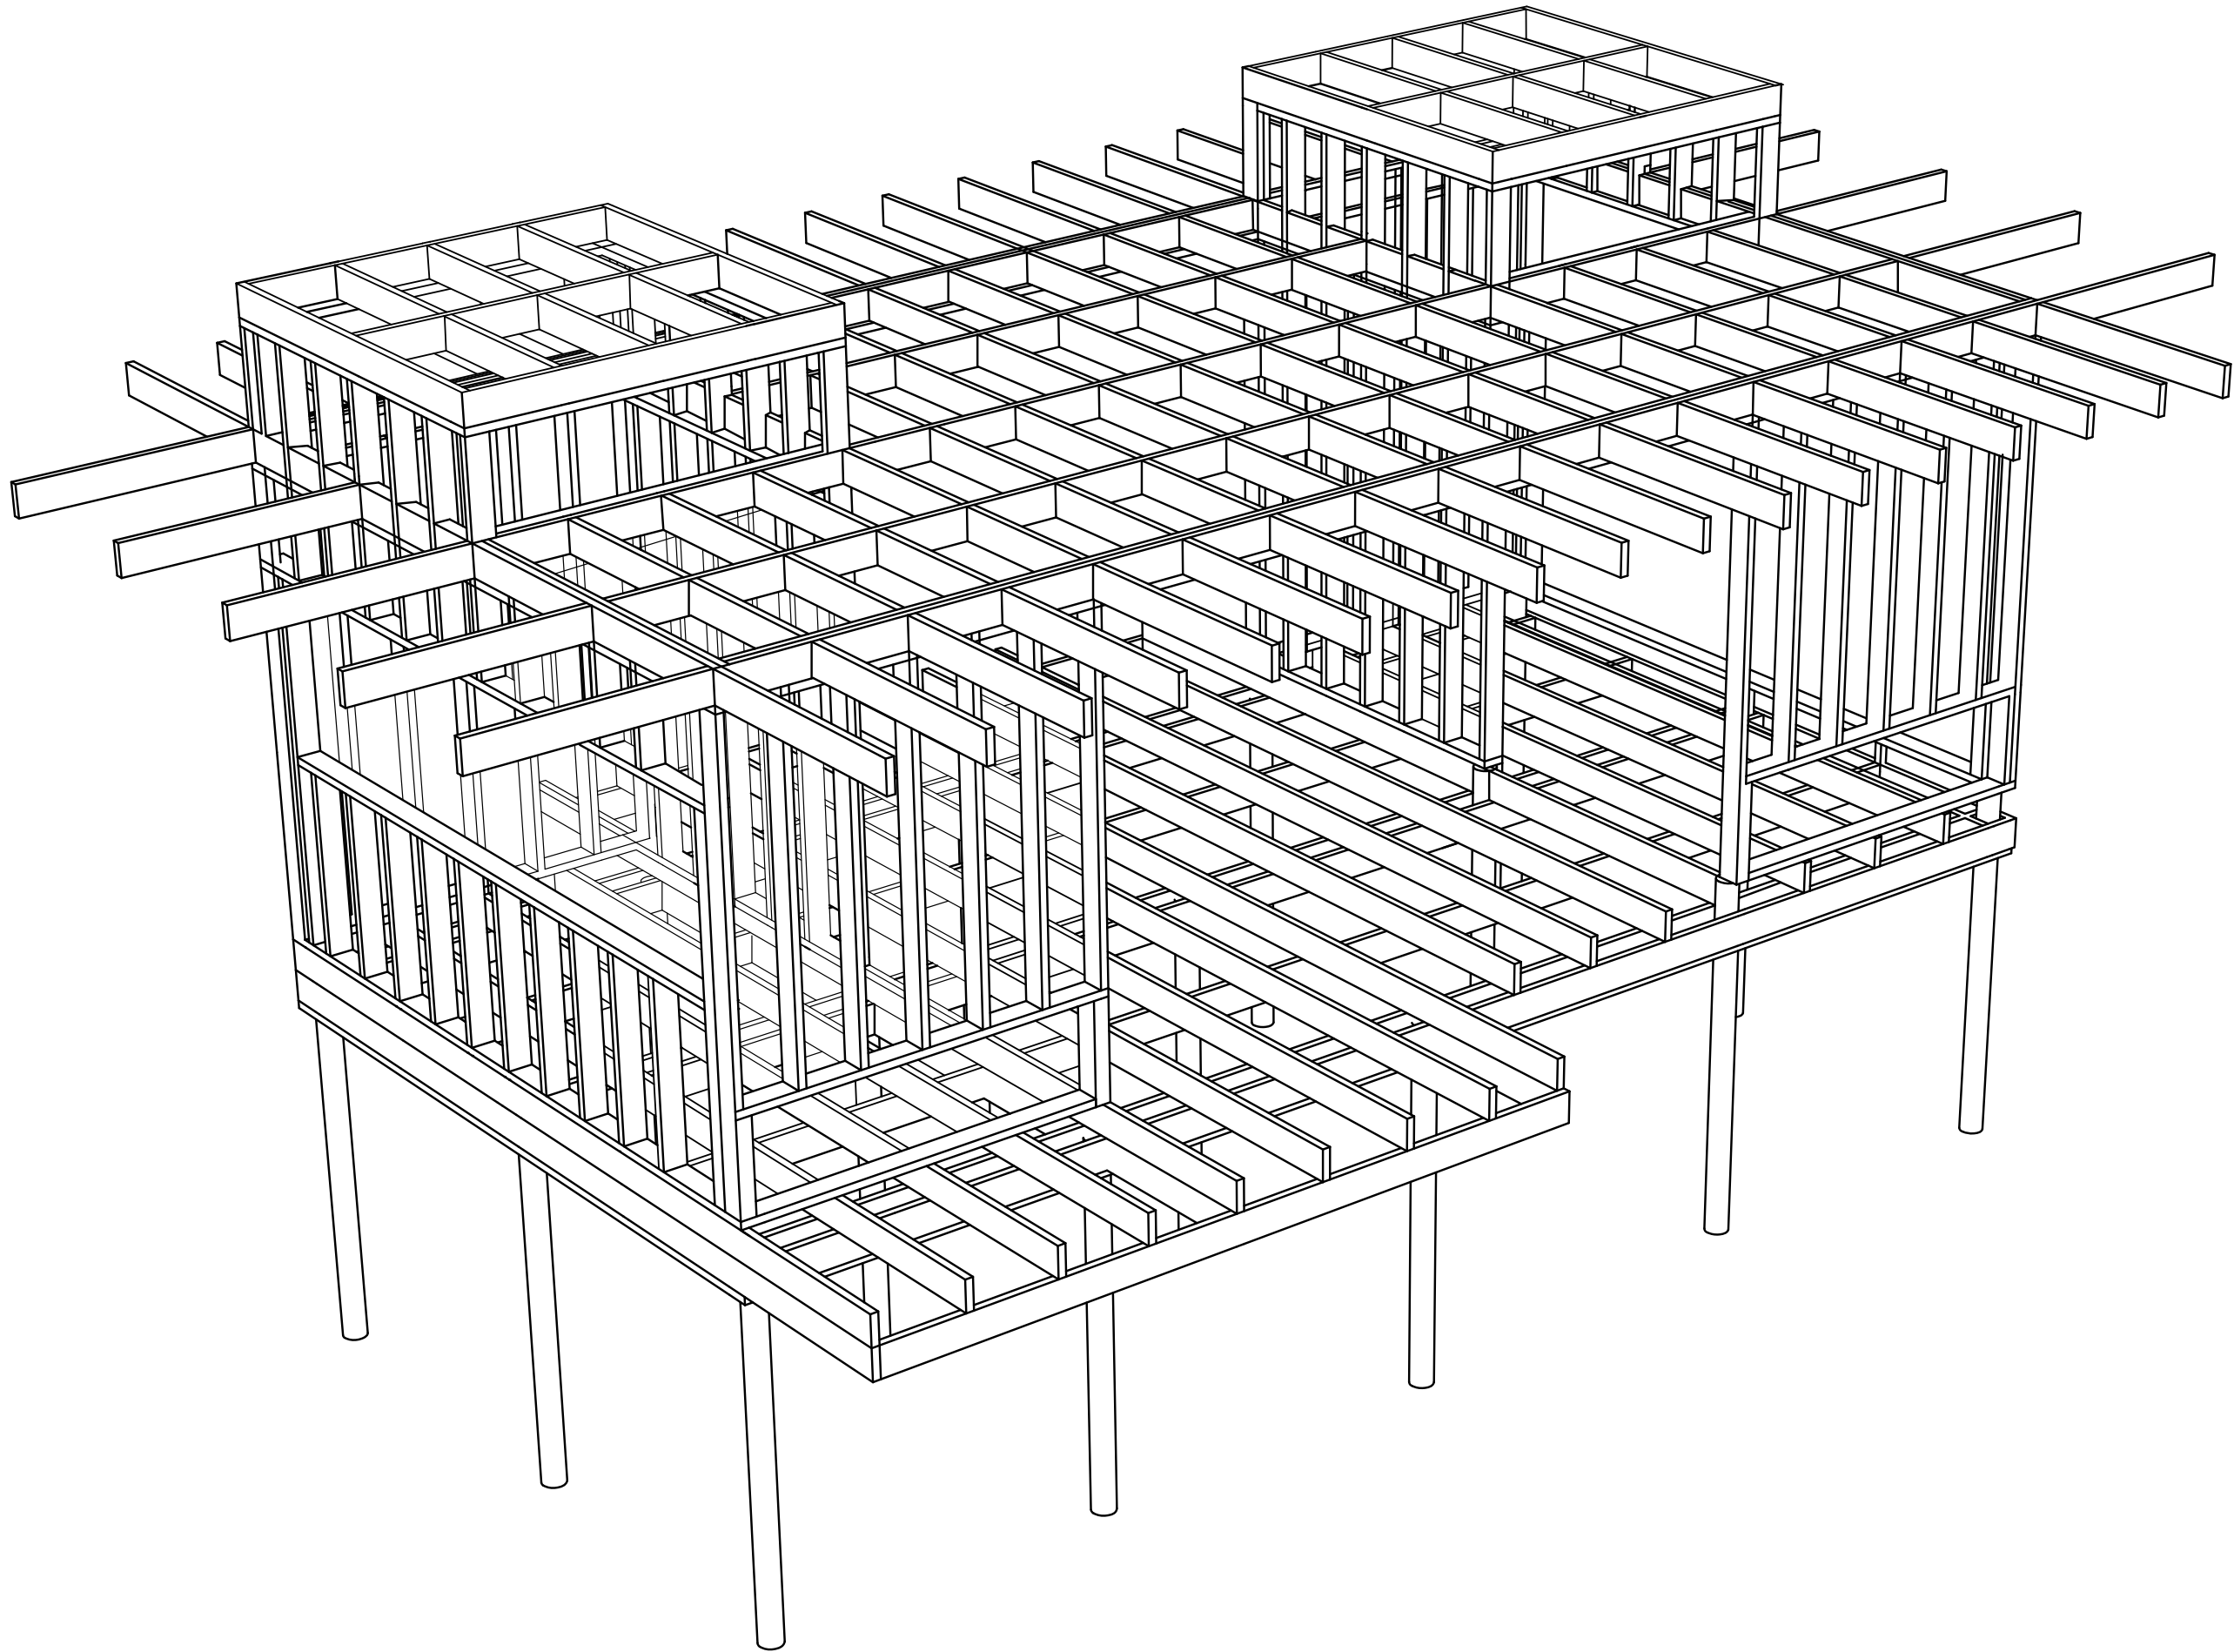

MATERIALS AND ASSEMBLY  
HOT & HUMID  
BRASILIA, BRAZIL

S1.5

Structure Overview


FINAL SUBMISSION  
APRIL 23,  
2009

Sara Gotschewski

Kevin Rodriguez

Ryan Ralston

SKR  
ARCHITECTS

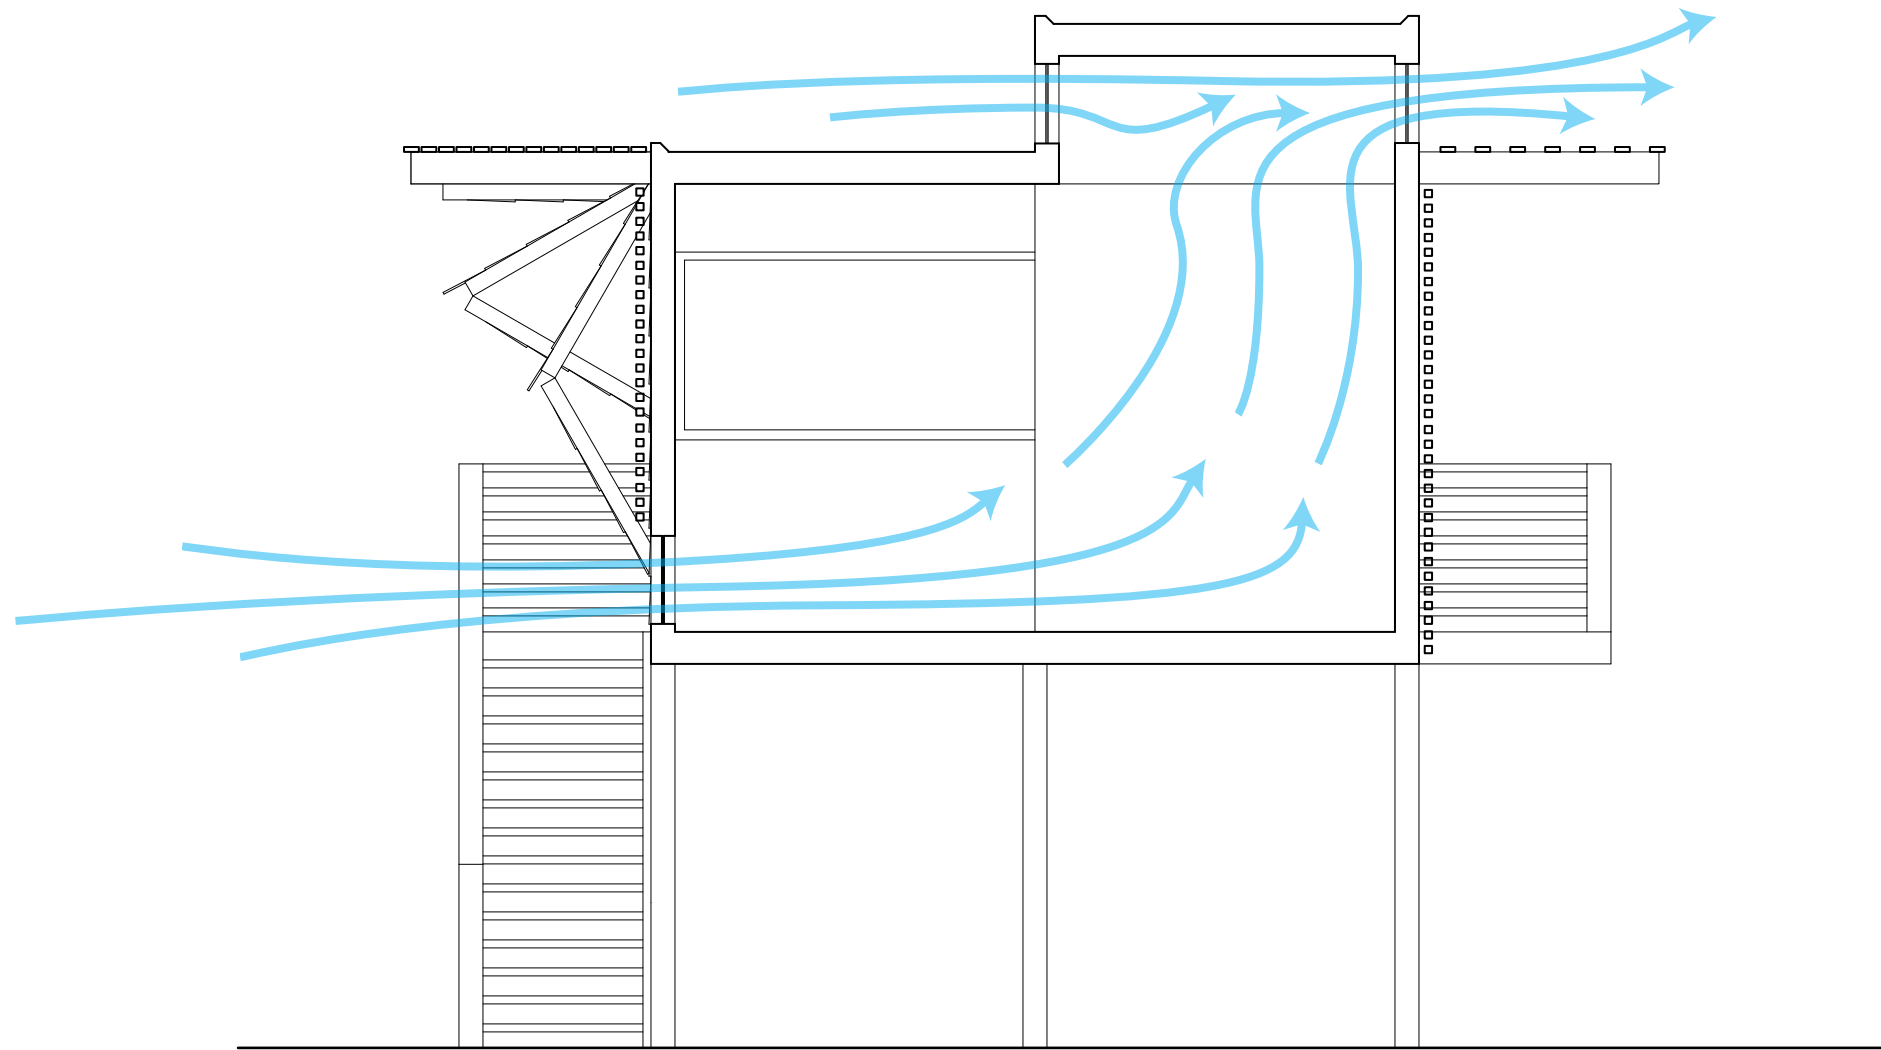

1 THERMAL FLOW DIAGRAM  
SCALE 1/4" = 1'

MATERIALS AND ASSEMBLY  
HOT & HUMID  
BRASILIA, BRAZIL

M1.1  
Thermal Diagram

FINAL SUBMISSION  
APRIL 23,  
2009

Sara Gotschewski


Kevin Rodriguez

Ryan Ralston

SKR  
ARCHITECTS



SUMMER  
JANUARY 1st

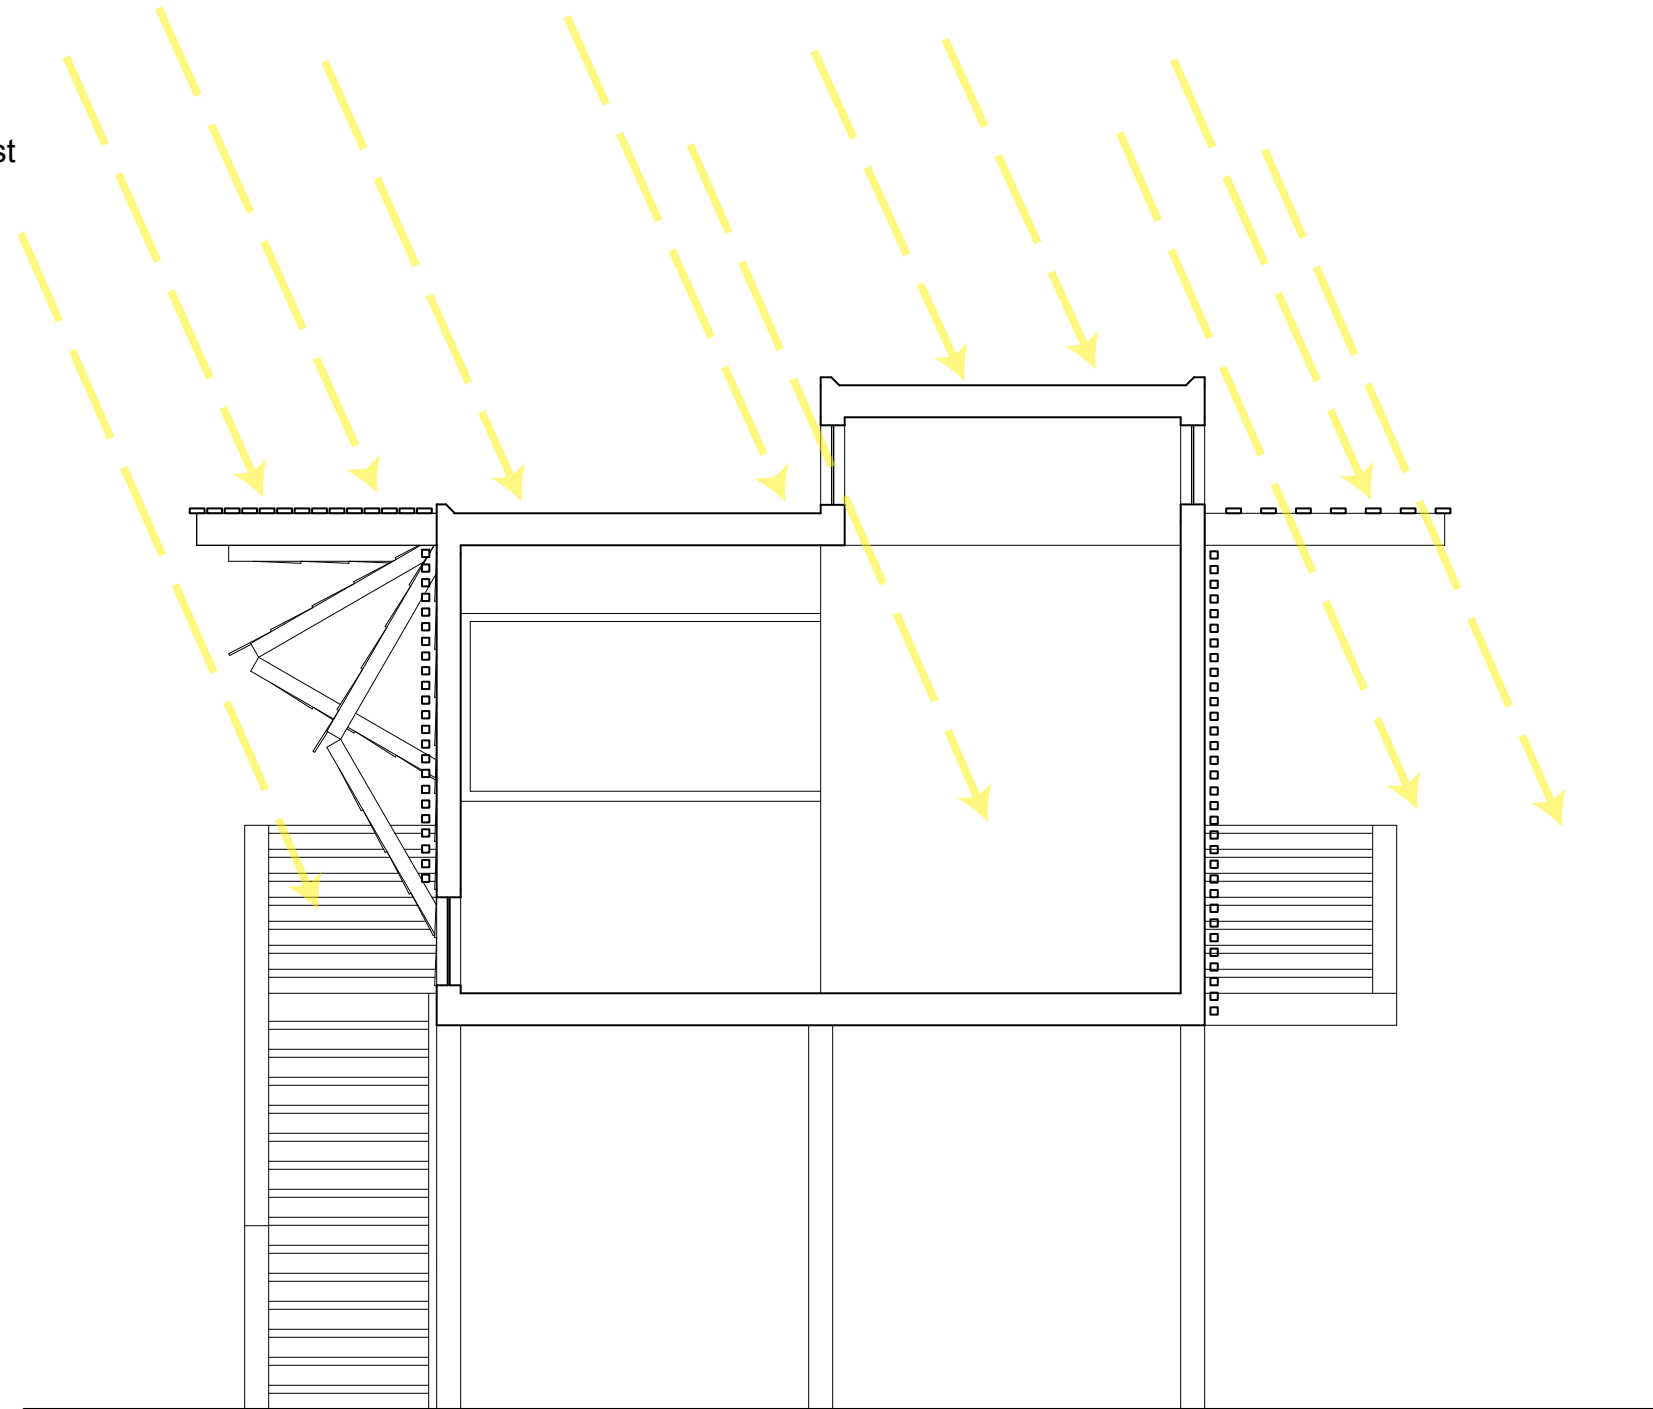

1

**PASSIVE LIGHTING DIAGRAM 1**

SCALE 1/4" = 1'

**MATERIALS AND ASSEMBLY**  
**HOT & HUMID**  
**BRASILIA, BRAZIL**

**M1.2**  
Lighting Diagram

FINAL SUBMISSION  
APRIL 23,  
2009


Sara Gotschewski

Kevin Rodriguez

Ryan Ralston

**SKR**  
ARCHITECTS

WINTER  
JULY 1st

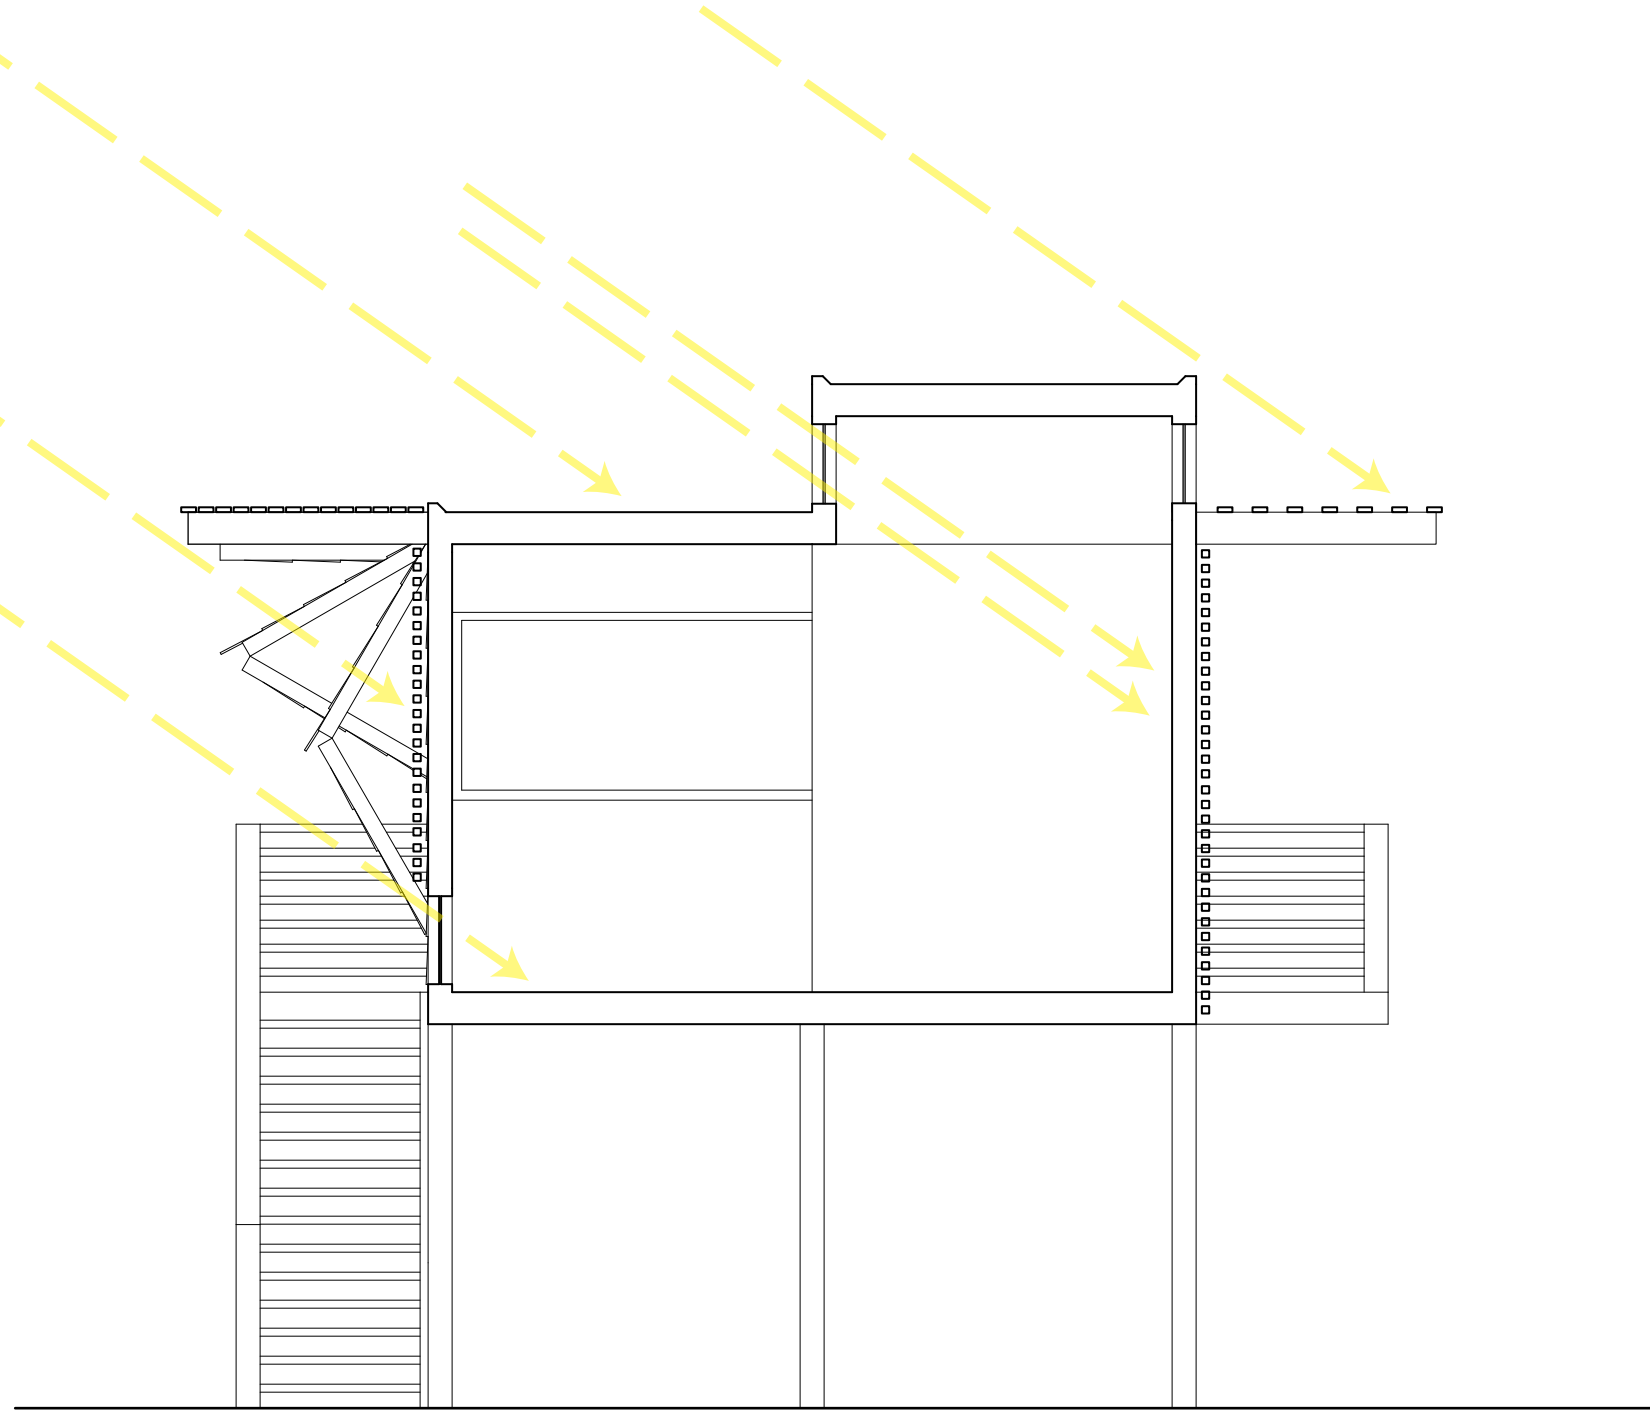

1

PASSIVE LIGHTING DIAGRAM 2

SCALE 1/4 " = 1'

MATERIALS AND ASSEMBLY  
HOT & HUMID  
BRASILIA, BRAZIL

M 1.3  
Lighting Diagram

FINAL SUBMISSION  
APRIL 23,  
2009

Sara Gotschewski

Kevin Rodriguez

Ryan Ralston

SKR  
ARCHITECTS